




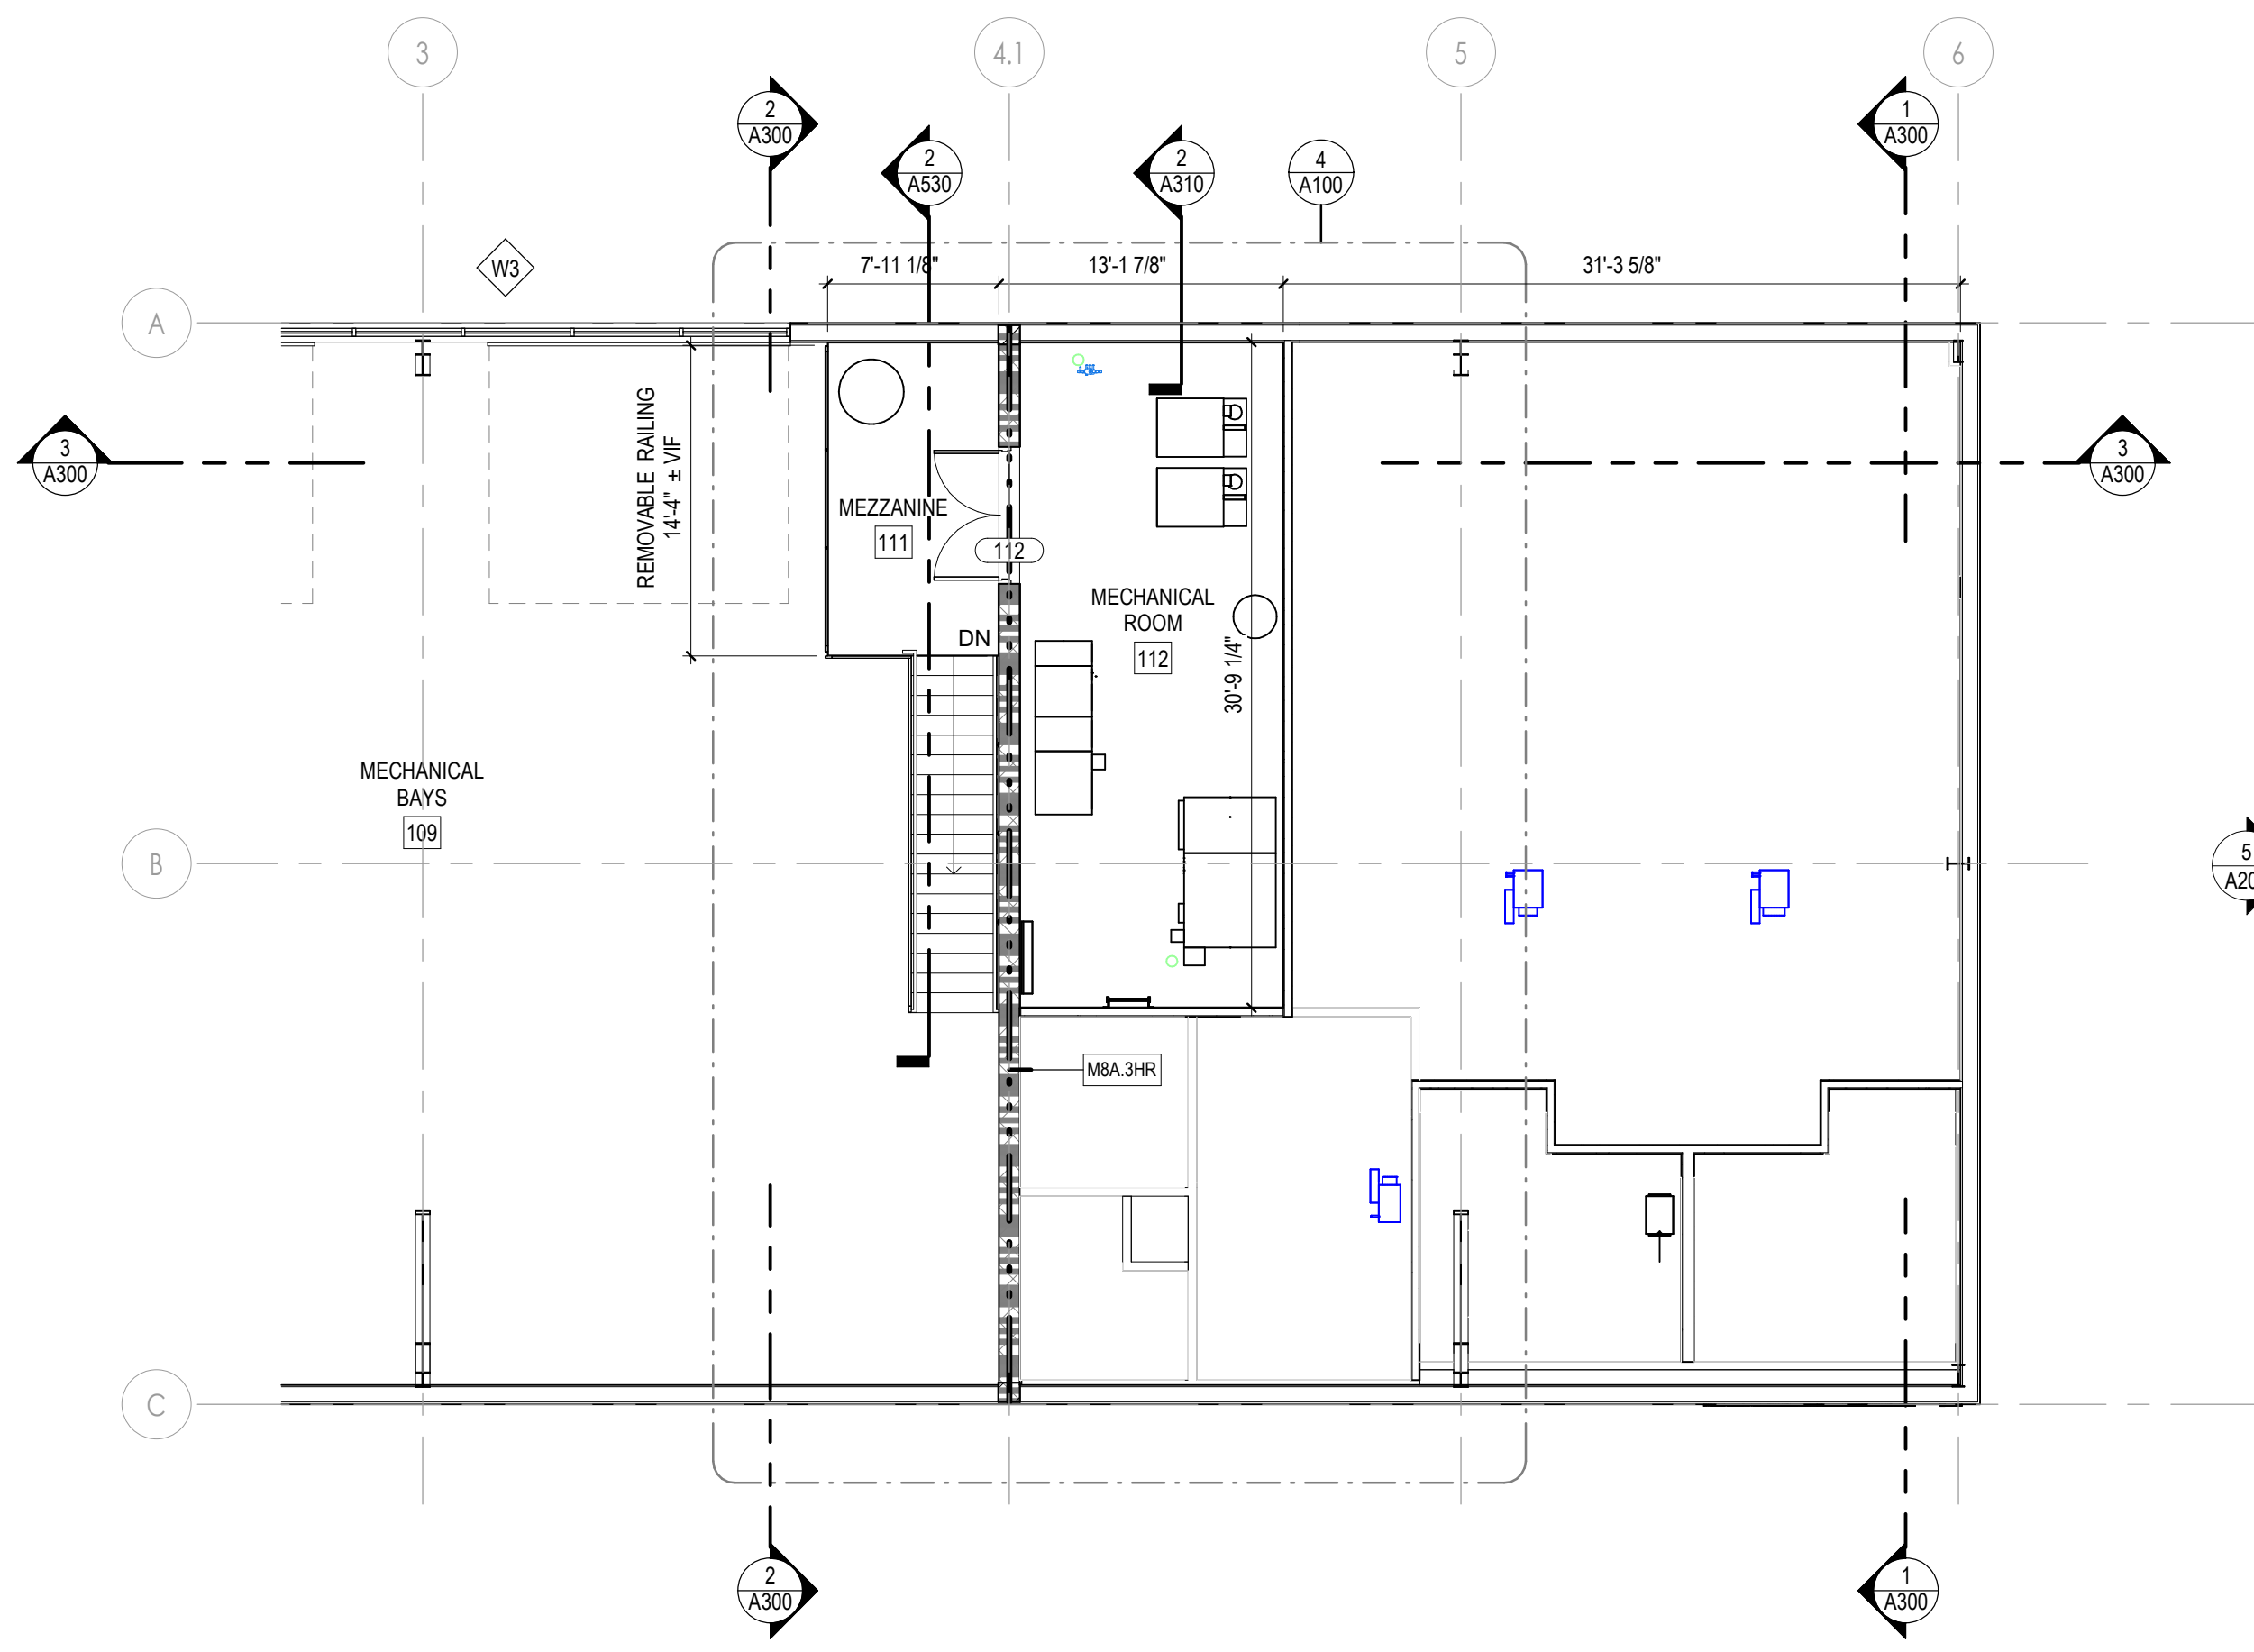


2 MEZZANINE PLAN
1/8" = 1'-0" REF: 3/ A200

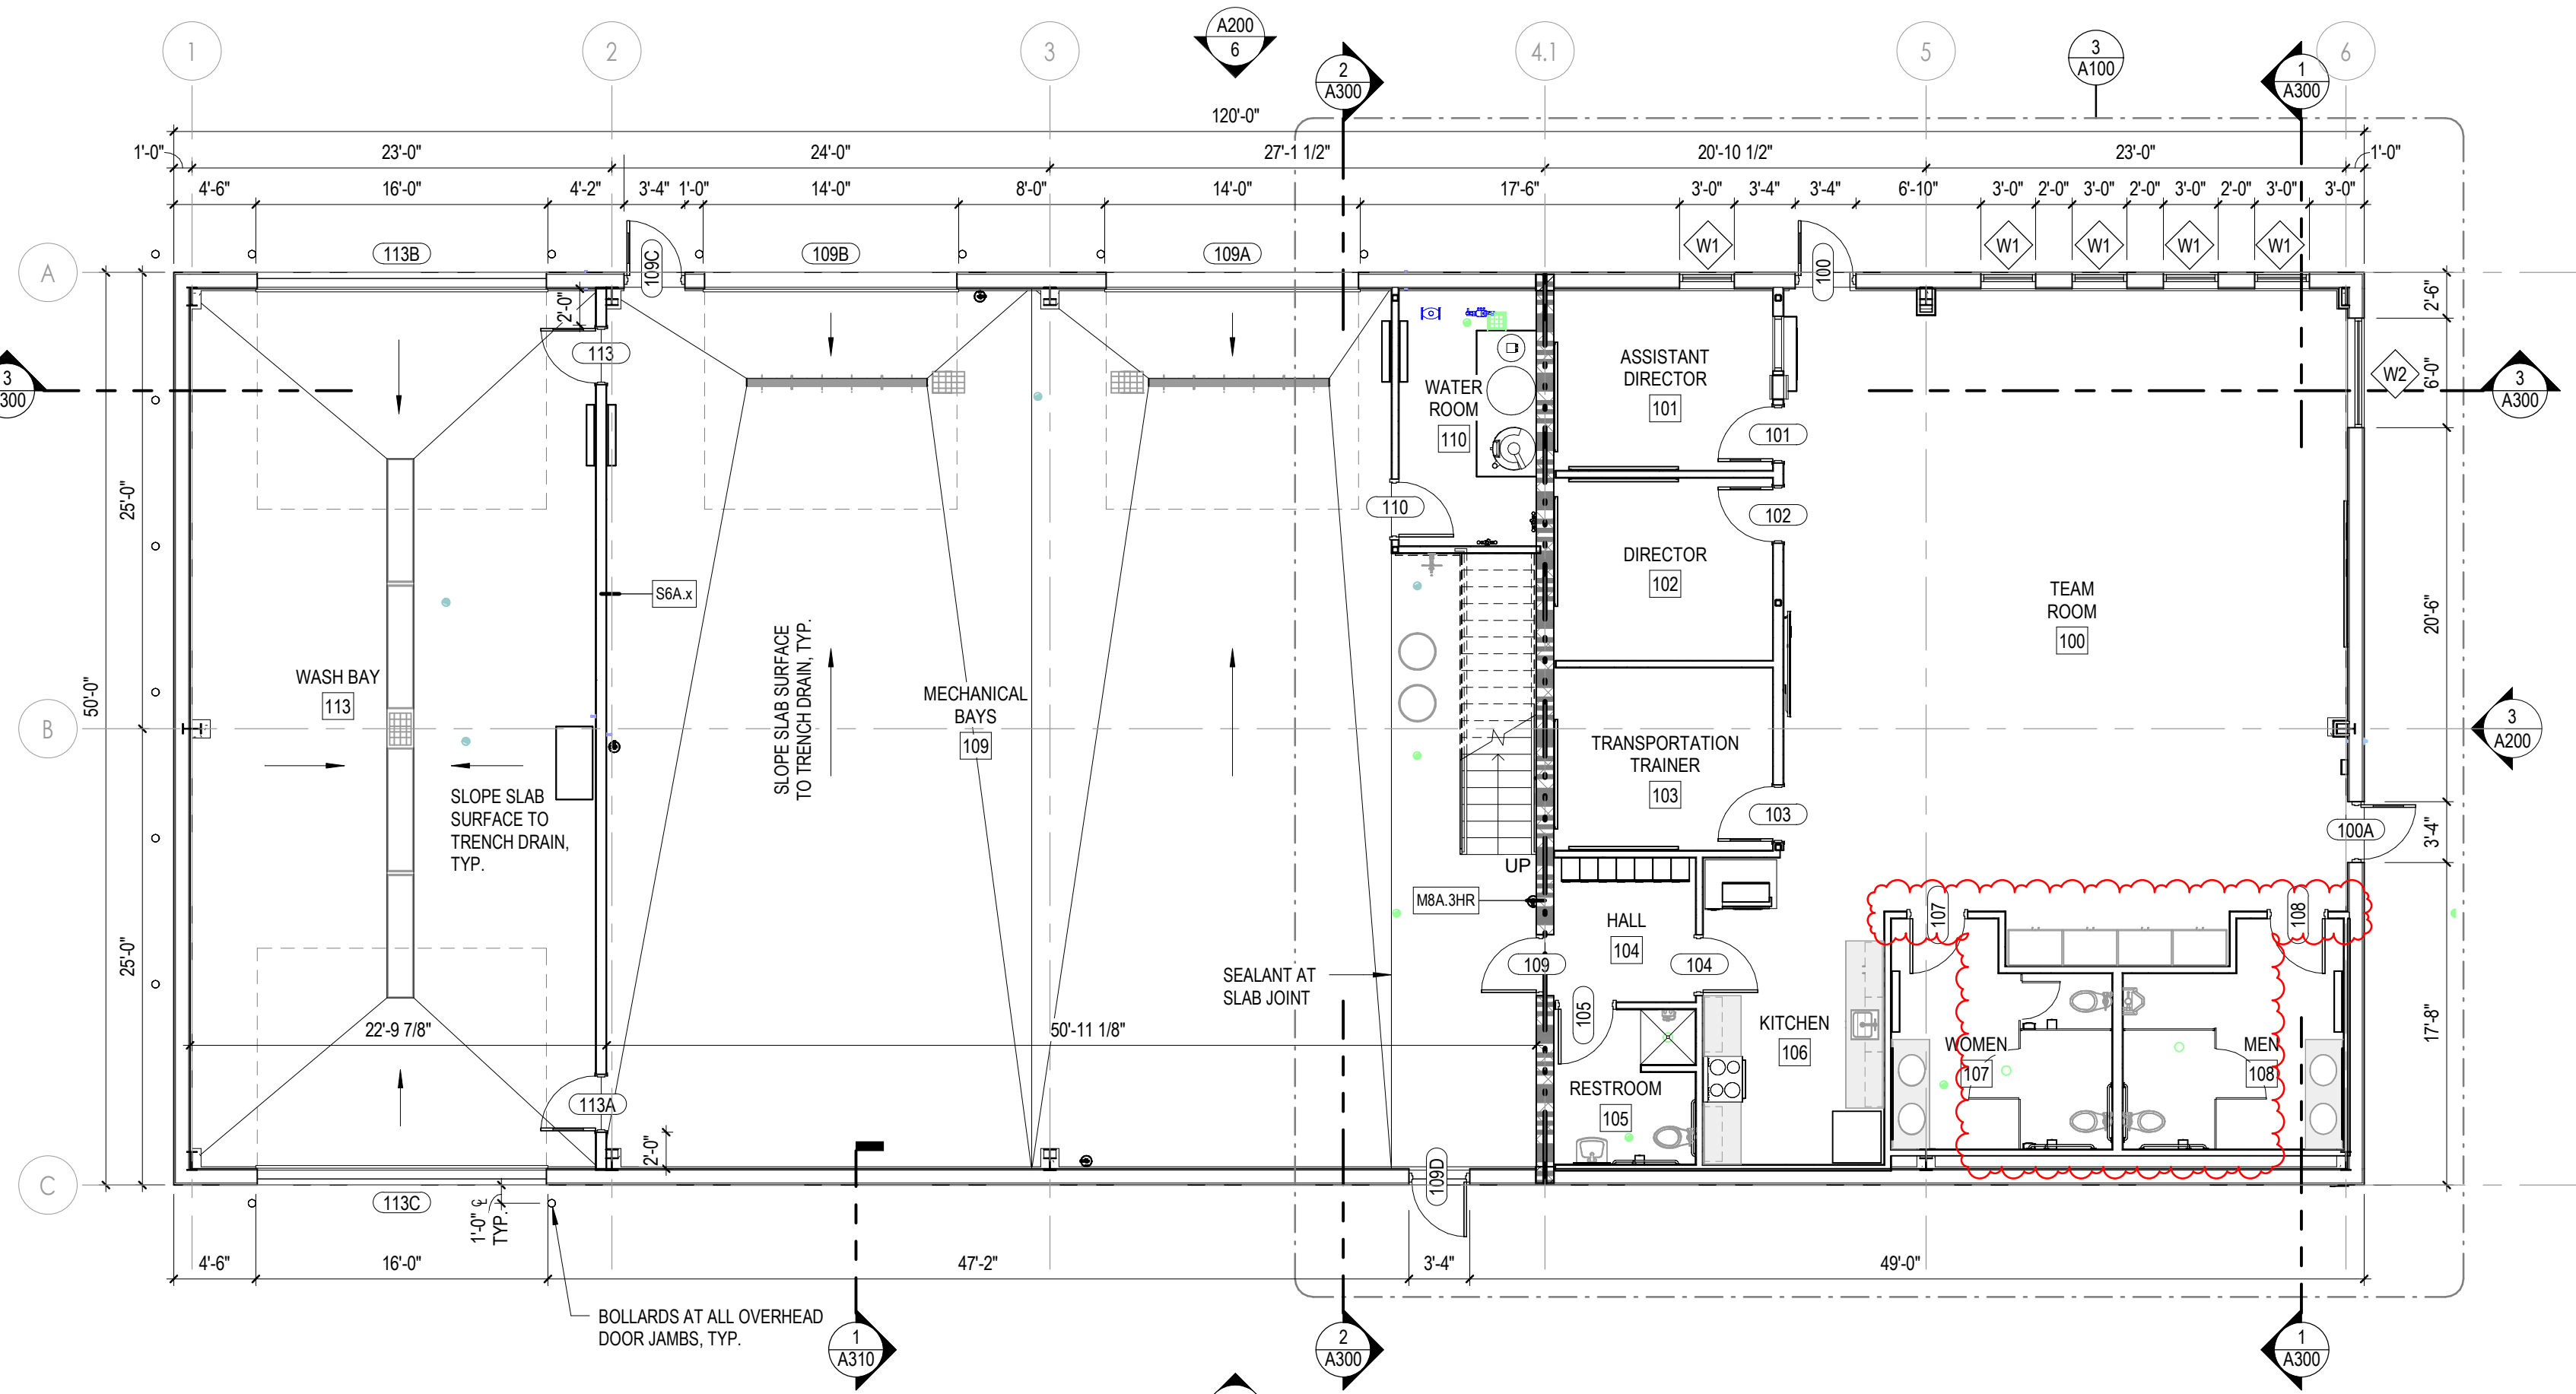

1 FIRST FLOOR PLAN
1/8" = 1'-0" REF: 3/ A200

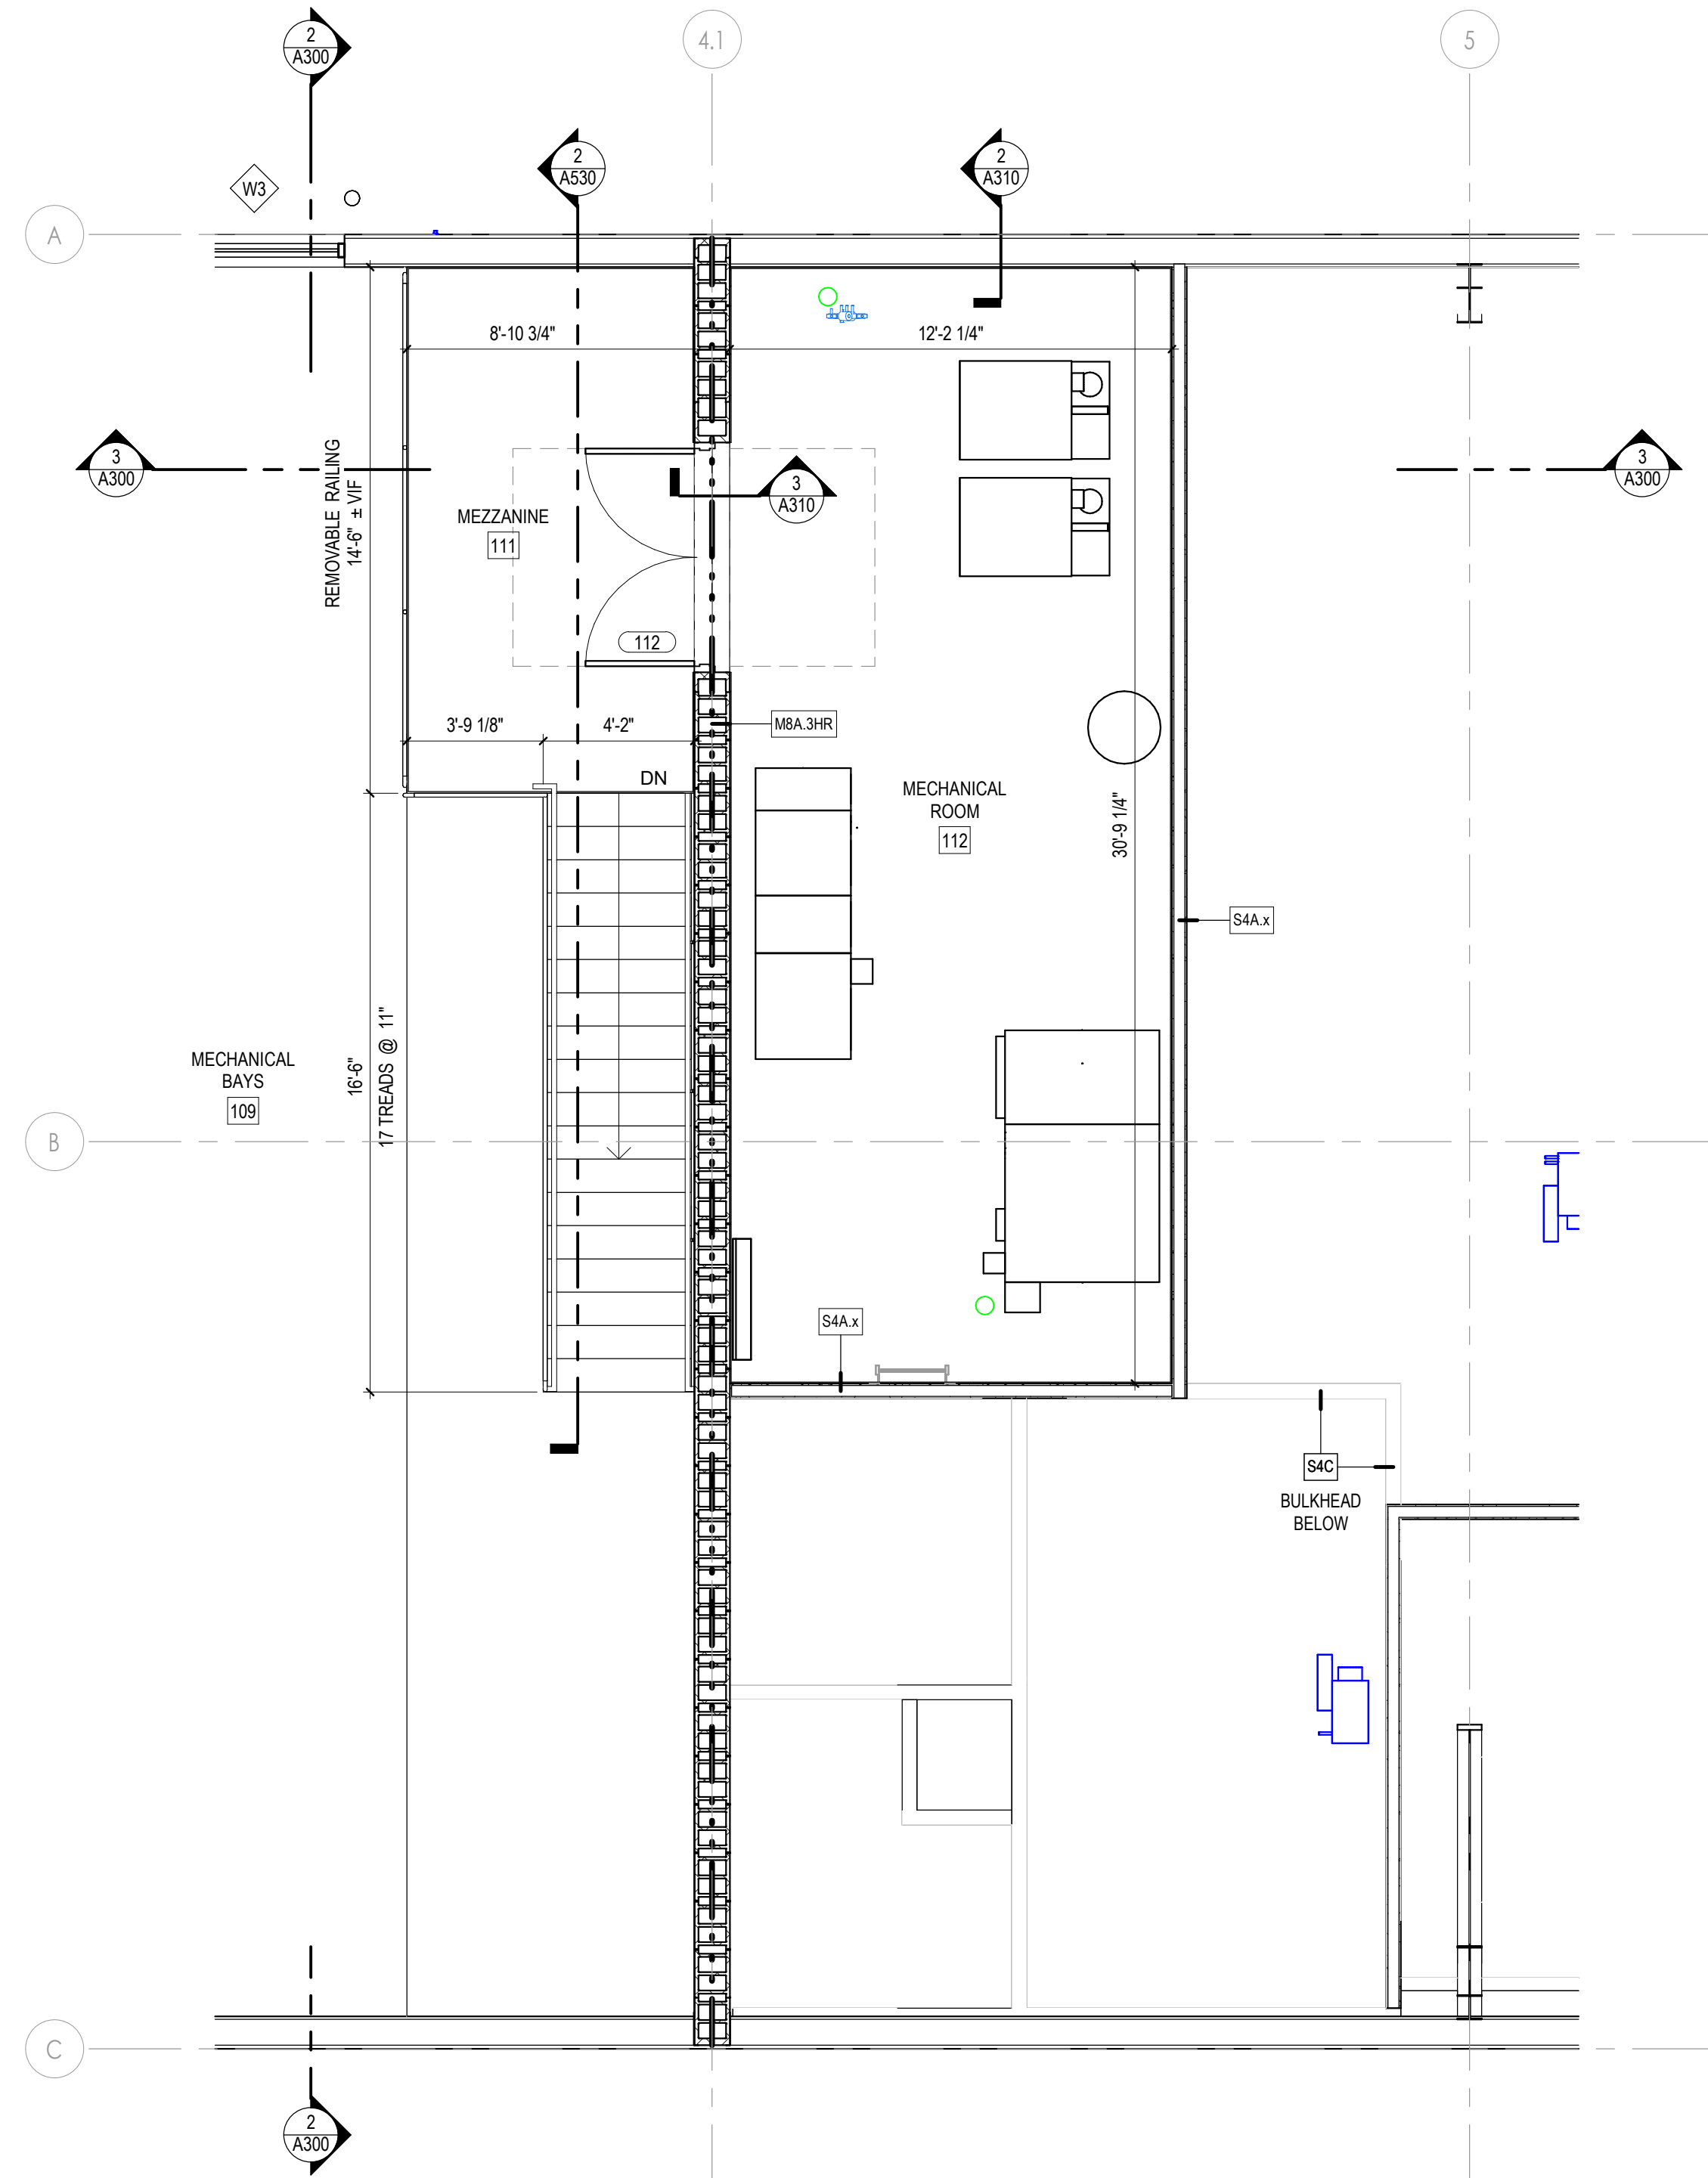


4 ENLARGED MEZZANINE PLAN - MECHANICAL ROOM
1/4" = 1'-0" REF: 2/ A100

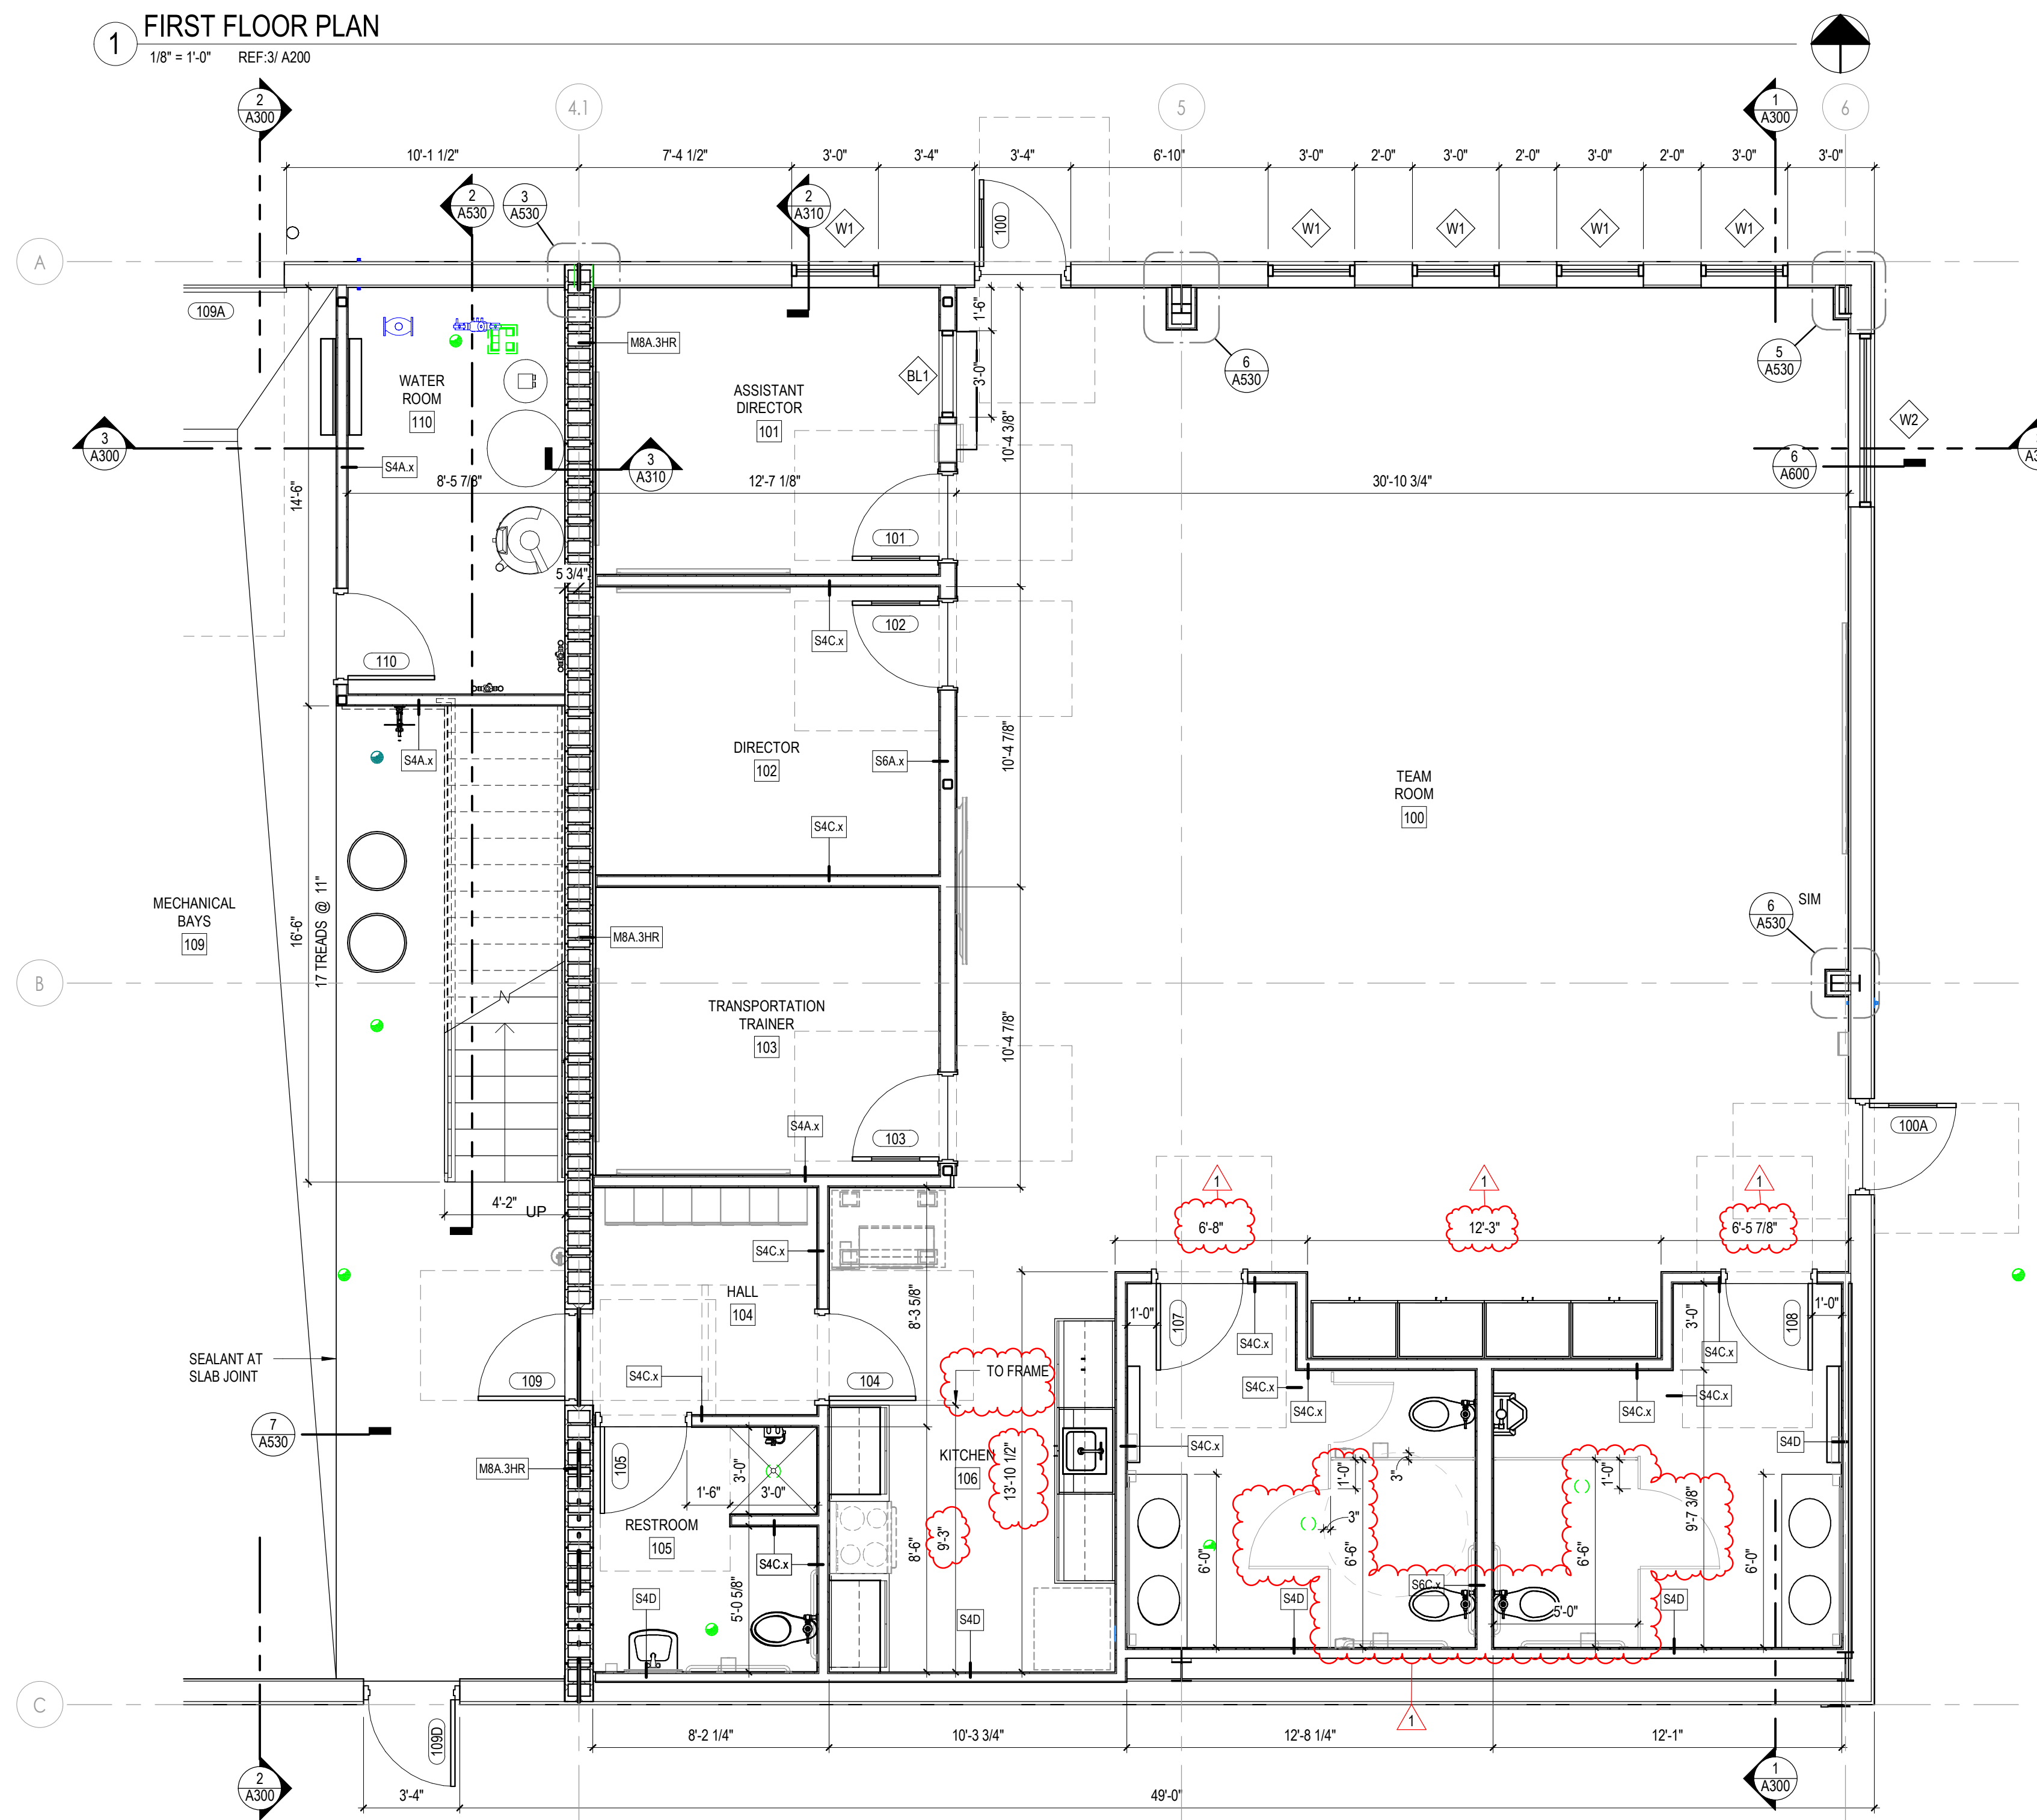

3 ENLARGED FIRST FLOOR PLAN - FRONT OFFICE
1/4" = 1'-0" REF: 1/ A100

GENERAL ARCHITECTURAL NOTES

- CONTRACTORS ARE REQUIRED TO REVIEW ENTIRE SET OF CONSTRUCTION DOCUMENTS (DRAWINGS AND SPECIFICATIONS) AND SHALL COORDINATE THEIR RESPECTIVE WORK WITH ALL OTHER DISCIPLINES TO AVOID ANY CONFLICTS DURING CONSTRUCTION. CONTRACTORS ARE RESPONSIBLE TO COORDINATE ARCHITECTURAL DRAWINGS WITH ALL OTHER CONSTRUCTION DOCUMENTS.
- CONFLICTS BETWEEN NOTES, DETAILS, SPECIFICATIONS, ETC., SHALL BE VERIFIED WITH ARCHITECT/ENGINEER (A/E).
- DETAILS OF CONSTRUCTION NOT FULLY SHOWN SHALL BE OF SAME NATURE AS SHOWN FOR SIMILAR CONDITIONS. ANY UNCLEAR CONDITIONS SHALL BE VERIFIED WITH A/E PRIOR TO CONSTRUCTION.
- CONTRACTORS ARE REQUIRED TO FIELD VERIFY EXISTING CONDITIONS AND DIMENSIONS PRIOR TO ANY FABRICATION OR CONSTRUCTION. IF EXISTING CONDITIONS ARE DIFFERENT THAN SHOWN, NOTIFY A/E IMMEDIATELY.
- DRAWINGS ARE NOT TO BE SCALED. ANY UNCLEAR DIMENSIONS OR DIMENSIONAL DISCREPANCIES SHALL BE VERIFIED WITH A/E.
- CONSTRUCTION DOCUMENTS REPRESENT FINISHED DESIGN INTENT AND DO NOT INDICATE METHOD OF CONSTRUCTION. CONTRACTORS SHALL PROVIDE ALL MEASURES NECESSARY TO PROTECT NEW AND EXISTING WORK DURING CONSTRUCTION.
- WHERE NEW WORK REQUIRES MODIFICATION OF EXISTING CONSTRUCTION, INCLUDE ALL WORK NECESSARY FOR A COMPLETE AND FINISHED ASSEMBLY, INCLUDING BUT NOT LIMITED TO: DEMOLITION, RE-FRAMING/SUPPORT, PATCHING, AND REFINISHING TO MATCH EXISTING.
- CONTRACTORS ARE RESPONSIBLE FOR PREPARATIONS OF FLOORS, WALLS, AND CEILINGS AS REQUIRED FOR NEW FINISHES. REFER TO GENERAL DEMOLITION AND INTERIOR FINISH NOTES FOR ADDITIONAL INFORMATION.
- UNLESS NOTED OTHERWISE, PATCH AND REPAIR FLOOR FLUSH WITH ADJACENT FLOOR SURFACE AS REQUIRED. FILL ANY SLOPING OR RECESSED AREAS LEVEL TO TYPICAL FINISH FLOOR ELEVATION TO ACCOMMODATE NEW FLOOR COVERINGS.
- PATCH ALL EXPOSED INTERIOR AND EXTERIOR WALLS WHERE ATTACHED OR IMBEDDED ITEMS WERE REMOVED.
- WHEN REMOVING DEBRIS FROM CONSTRUCTION AREA Wipe OFF WHEELS BEFORE LEAVING CONSTRUCTION AREA AND USE WET RAGS OVER DUMPSTER TO REDUCE DUST.
- OWNER RESERVES RIGHT TO HALT CONSTRUCTION ACTIVITY AT ANY TIME DUE TO NOISE/VIBRATION WHICH MAY EFFECT ONGOING FACILITY USE.
- CONTRACTORS SHALL REINSTATE CEILING SYSTEM AND PATCH FINISHES AT FLOOR BELOW AND ABOVE WHERE WORK IMPACTS EXISTING ASSEMBLIES. FINISH/PATCH SURFACES TO MATCH EXISTING FINISHES.
- ALL DIMENSIONS ARE TO FACE OF DRYWALL, FACE OF BLOCK OR CONCRETE, OR TO FACE OF EXISTING WALL FINISH, UNLESS NOTED OTHERWISE.
- COORDINATE LOCATION OF ALL RECESSED OR IMBEDDED ITEMS SO AS NOT TO INTERFERE WITH OTHER TRADES WORK.
- MAINTAIN WALL FIRE RATING BEHIND RECESSED ACCESSORIES AND EQUIPMENT.
- ADDITIONS OF OPENINGS, PENETRATIONS OR EMBEDMENTS IN FIELD SHALL BE FIRST VERIFIED WITH A/E.
- PROVIDE NEOPRENE OR VINYL ISOLATION MATERIAL BETWEEN DISSIMILAR METALS THAT ARE IN CONTACT WITH ONE ANOTHER, TYPICAL UNLESS NOTED OTHERWISE.
- PROVIDE SOLID, CONTINUOUS BLOCKING/STRAPPING OR EQUIVALENT BACKING SYSTEM AS REQUIRED AT ALL LOCATIONS WHERE ALL WALL MOUNTED CABINETRY, MILLWORK, PLUMBING FIXTURES, ACCESSORIES, EQUIPMENT, ETC. ATTACHES TO WALL. REFER TO SPECIFICATIONS.
- ALL BLOCKING SHALL BE FIRE RETARDANT TREATED WOOD OR MADE OF NON-COMBUSTIBLE MATERIAL.
- WHERE DRYWALL ABUTS DISSIMILAR MATERIALS, USE METAL DRYWALL EDGE BEAD AND SEALANT WITH BACKER ROD UNLESS NOTED OTHERWISE.
- ALL HEADERS ABOVE OPENINGS, DOORS AND BORROWED LITES IN NON-LOAD BEARING INTERIOR METAL STUD WALLS SHALL BE (2) 8" 18 GA. JOISTS UNLESS NOTED OTHERWISE.
- PROVIDE 18" MIN. ADA REQUIRED CLEARANCE ADJACENT TO STRIKE OF DOOR.
- PAINTING CONTRACTOR SHALL LABEL ABOVE CEILING ALL FIRE RATED WALL CONSTRUCTION AND SMOKE BARRIER WALL CONSTRUCTION IN ACCORDANCE WITH SPECIFICATION.
- FOLLOWING DEMOLITION OF EXISTING M.E.P. AND ARCHITECTURAL DEMOLITION, PATCH ALL UNUSED WALL PENETRATIONS AND RECESSES WITH STUD FRAMING/CLADDING AND GYPSUM WALLBOARD AS REQUIRED. FILL EXISTING VOIDS COMPLETE WITH SOUND BATT INSULATION. SEAL AS REQUIRED.

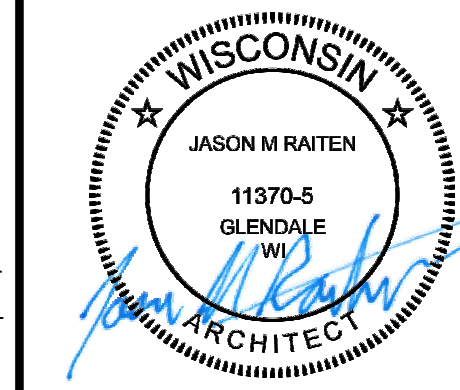

SIGNATURE

PROPRIETARY AND CONFIDENTIAL

This drawing and its contents are the property of Performance Services and shall not be reproduced in whole or in part by any means, mechanical or electronic, without express written permission.




New Construction of
EAST TROY TRANSPORTATION BUILDING
2021 West St., East Troy, WI 53120
EAST TROY COMMUNITY SCHOOLS
DESIGN BUILD

PSI PROJECT NO. 39D-K24-3839
DATE: 03 / 27 / 2026
DRAWN BY: DAB
CHECKED BY: JMR


1 06-12-2026 ASI 01
No. 05-11-2026 CONSTRUCTION SET
DATE DESCRIPTION

REVISIONS
CONSTRUCTION DOCUMENTS


SHEET
A100
FIRST FLOOR
ARCHITECTURAL PLAN

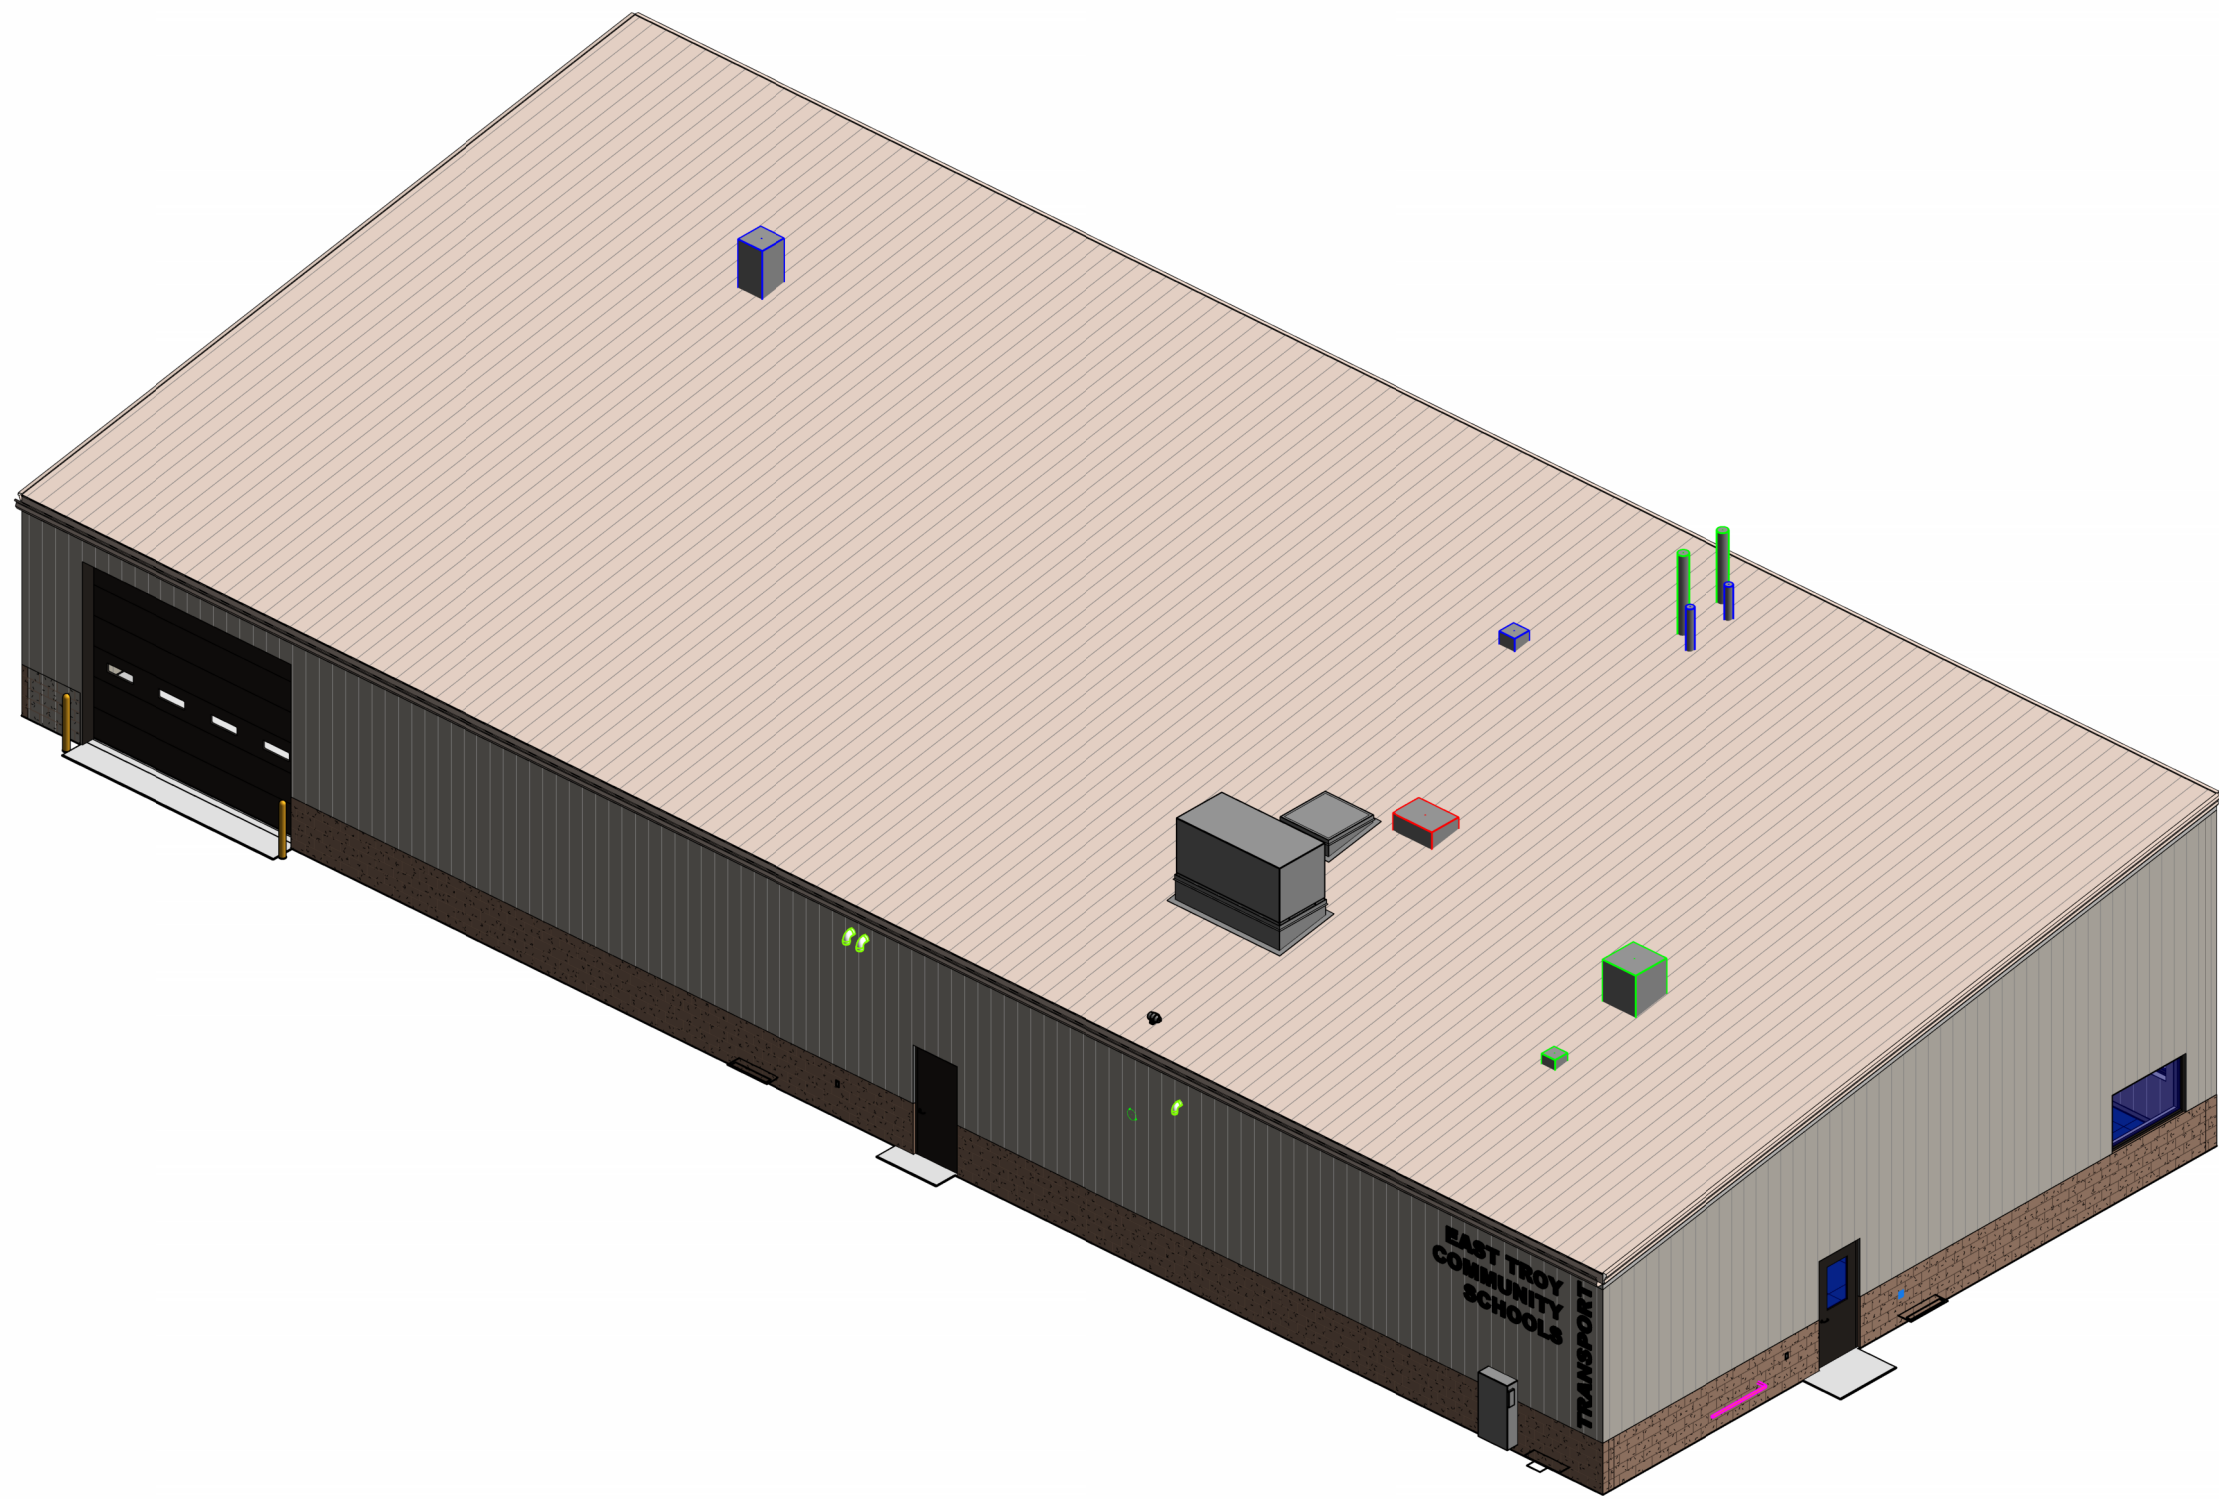

BUILDING AXON - SOUTHEAST CORNER

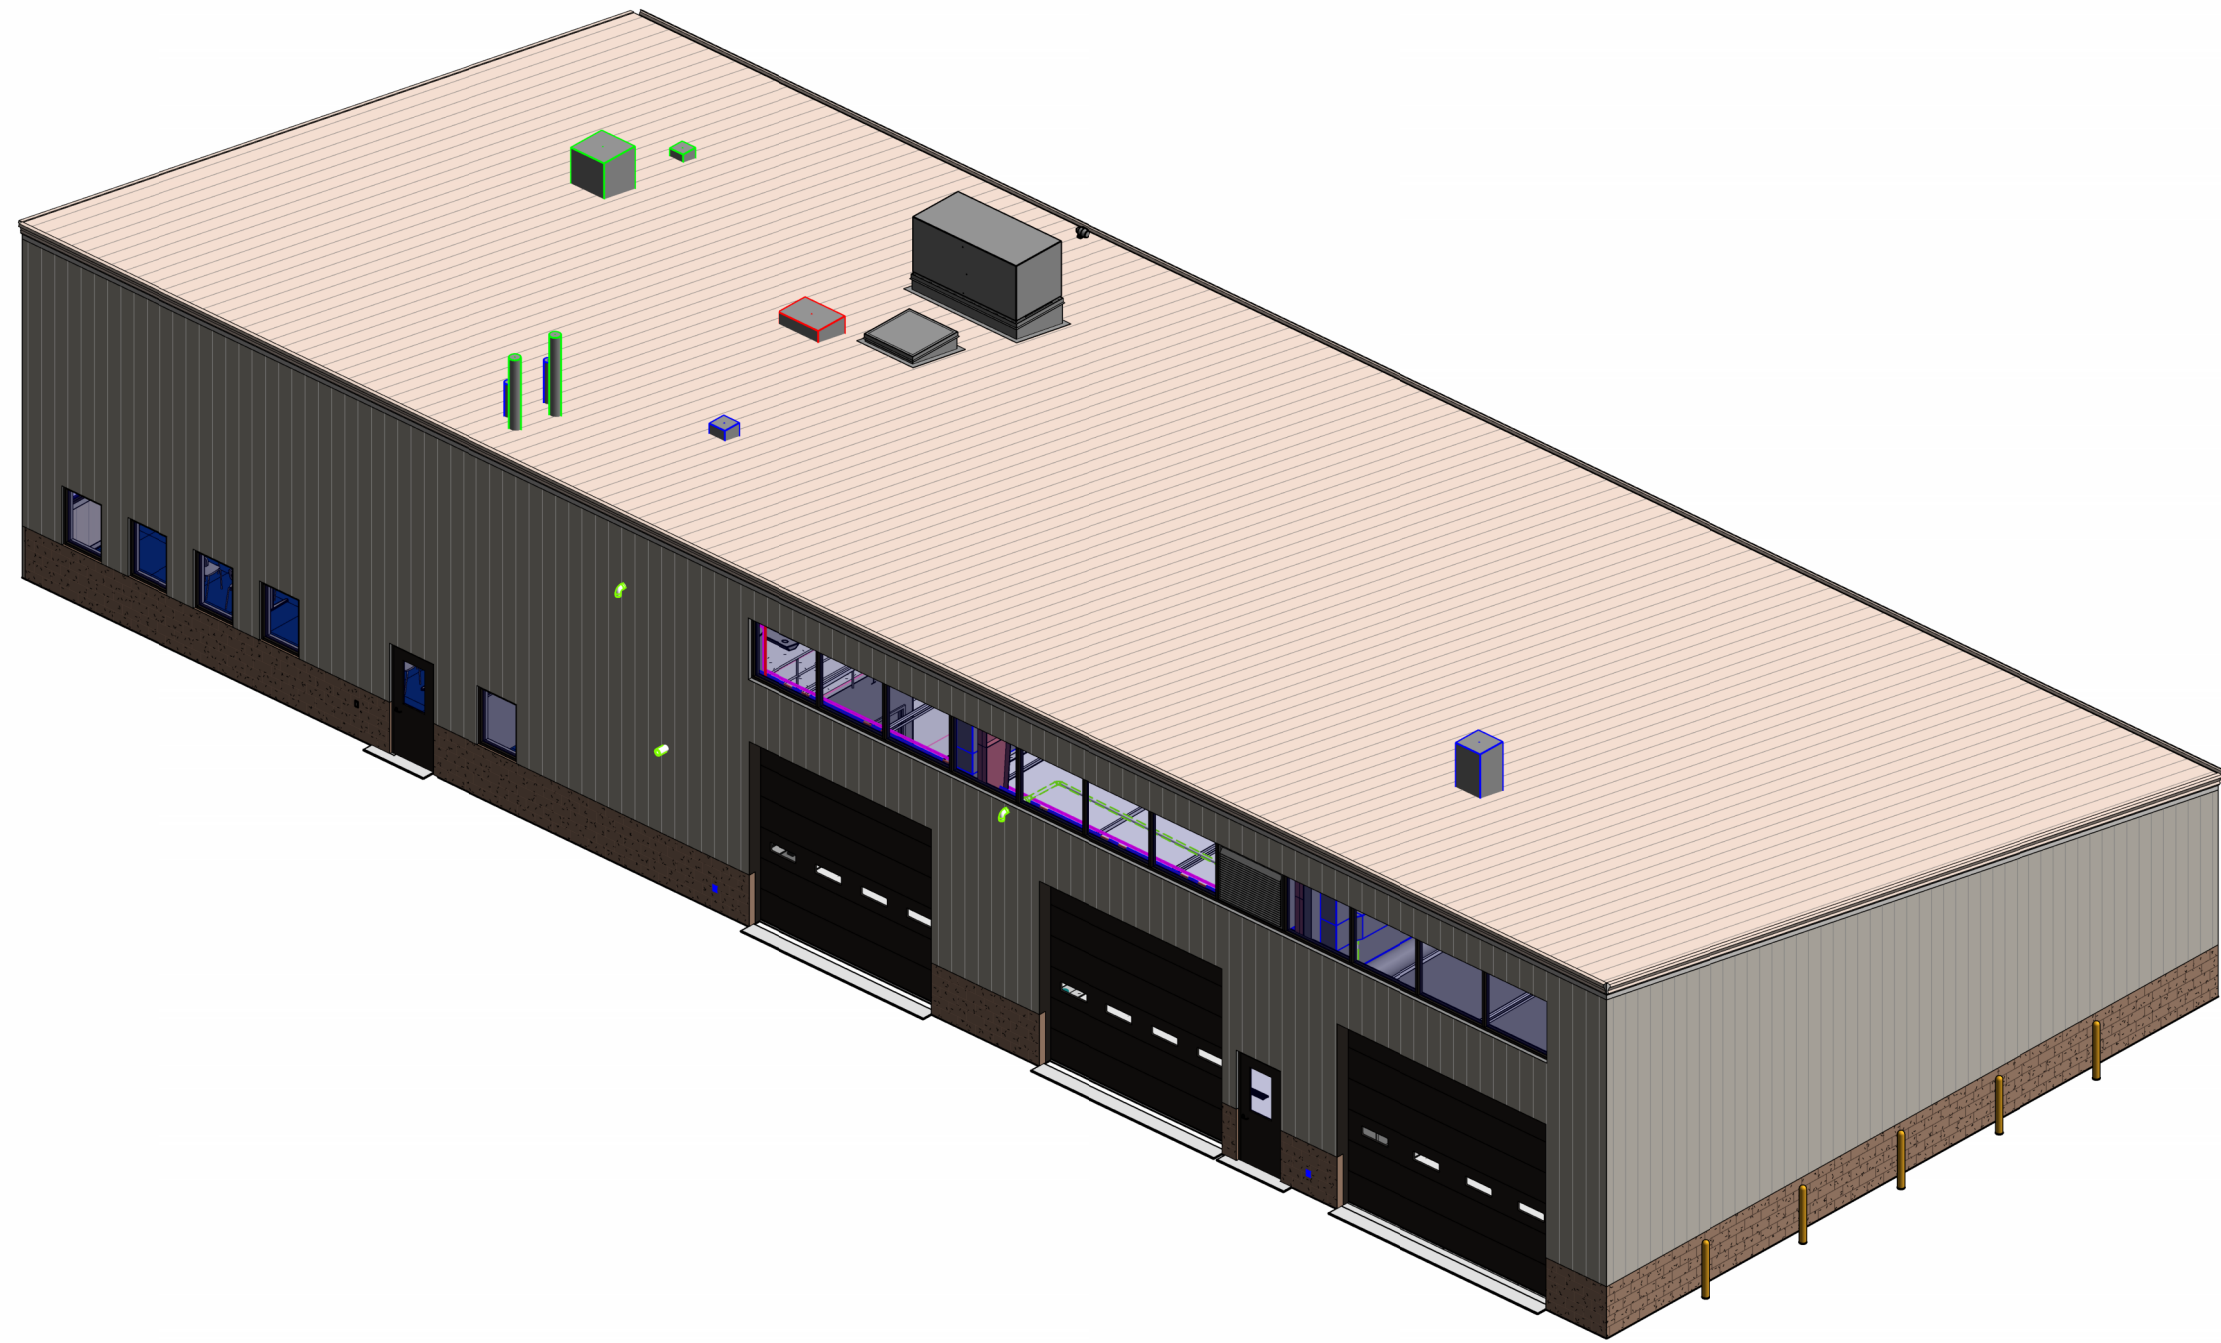


BUILDING AXON - NORTHWEST CORNER

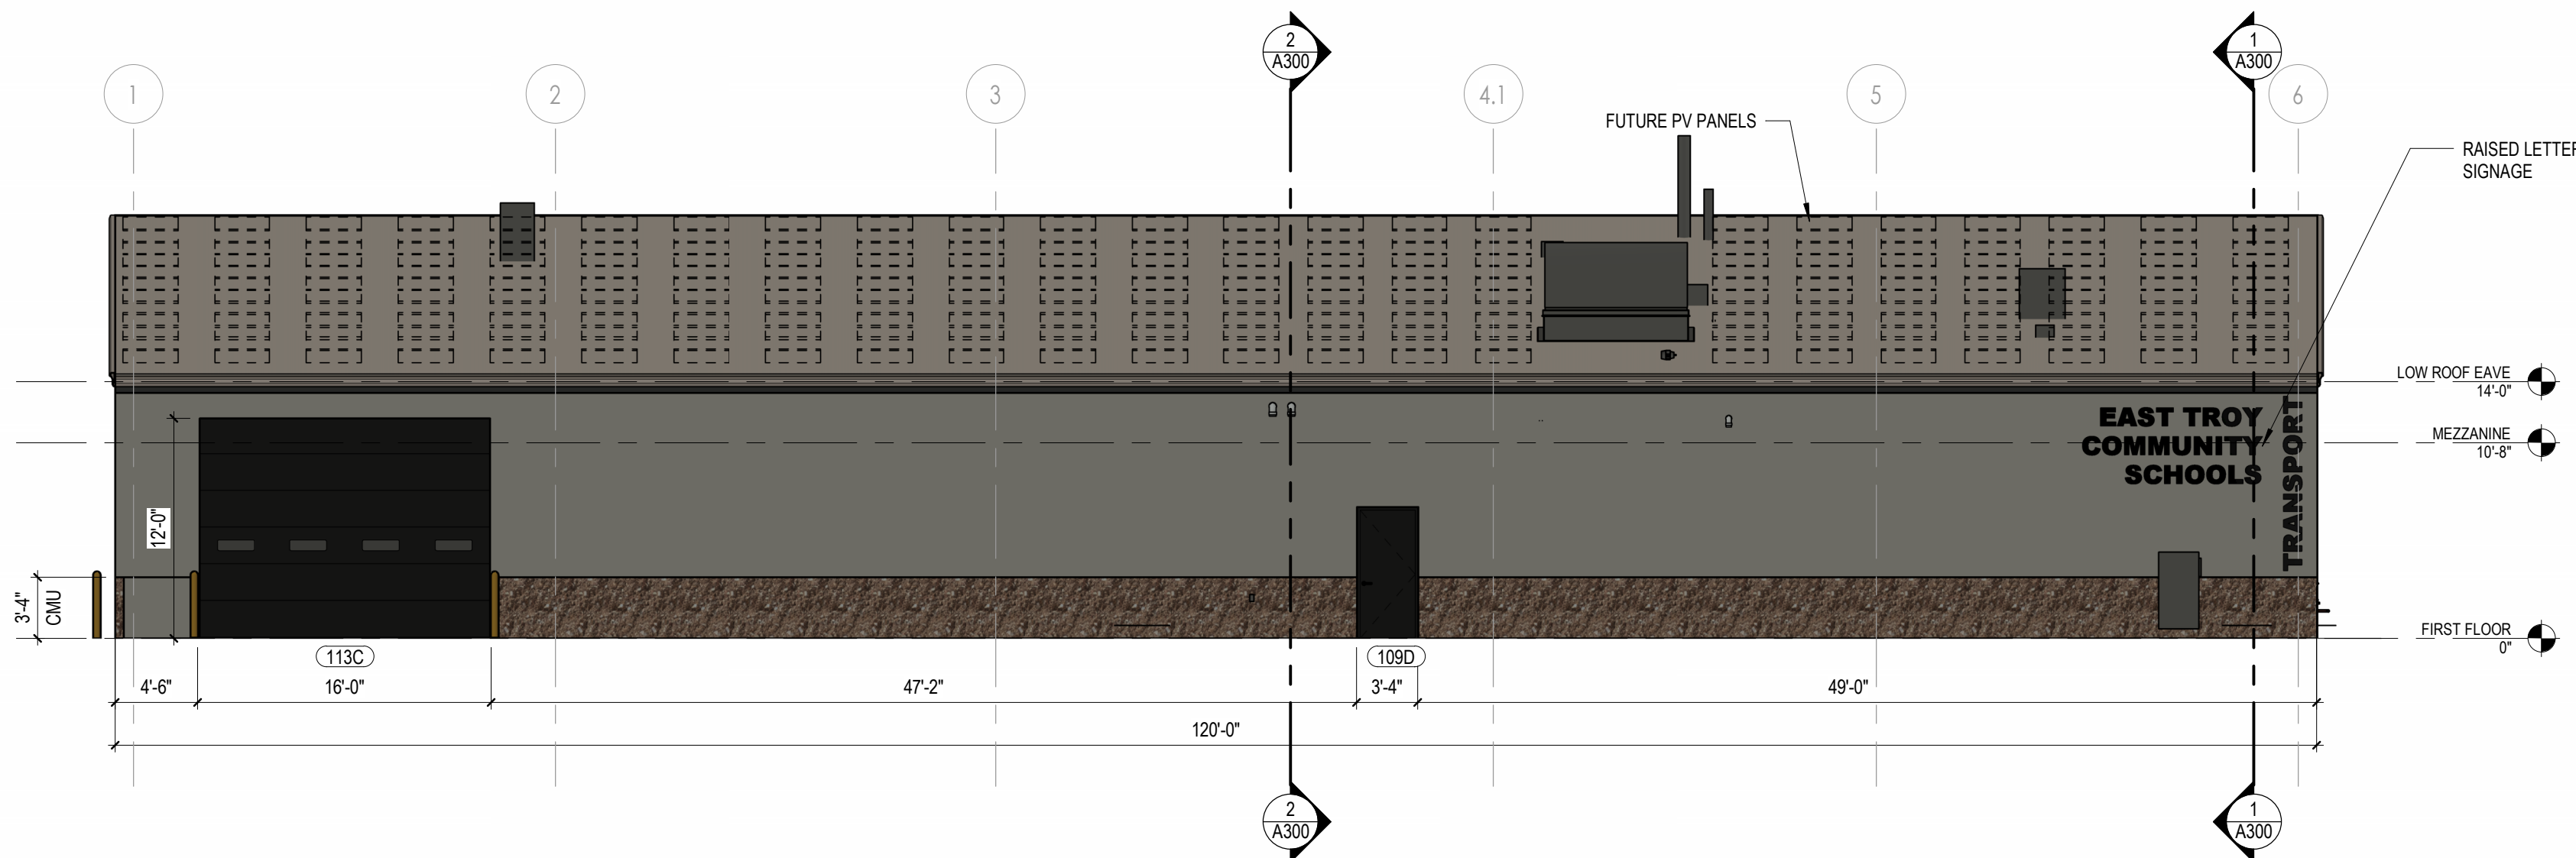


4 SOUTH ELEVATION

1/8" = 1'-0" REF: 1/ A100

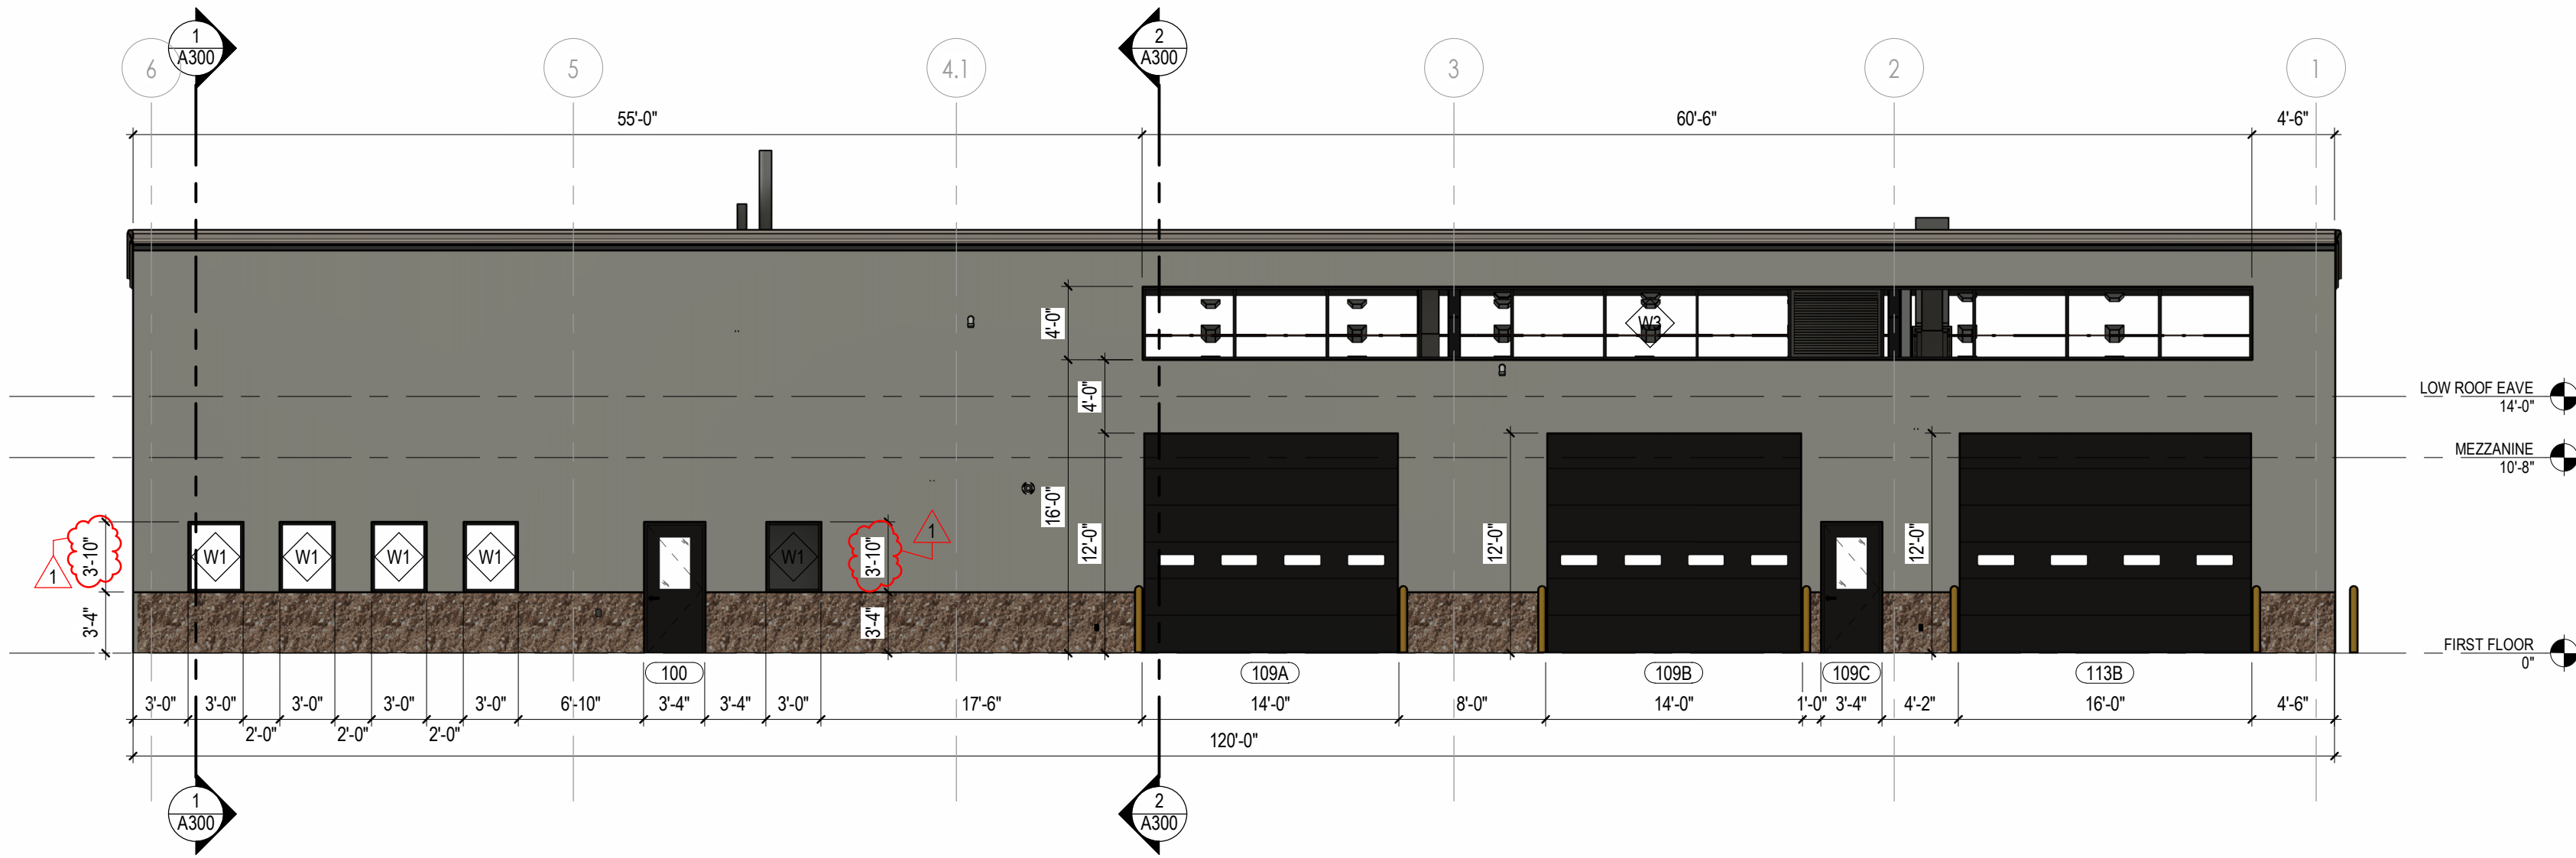


6 NORTH ELEVATION

1/8" = 1'-0" REF: 1/ A100

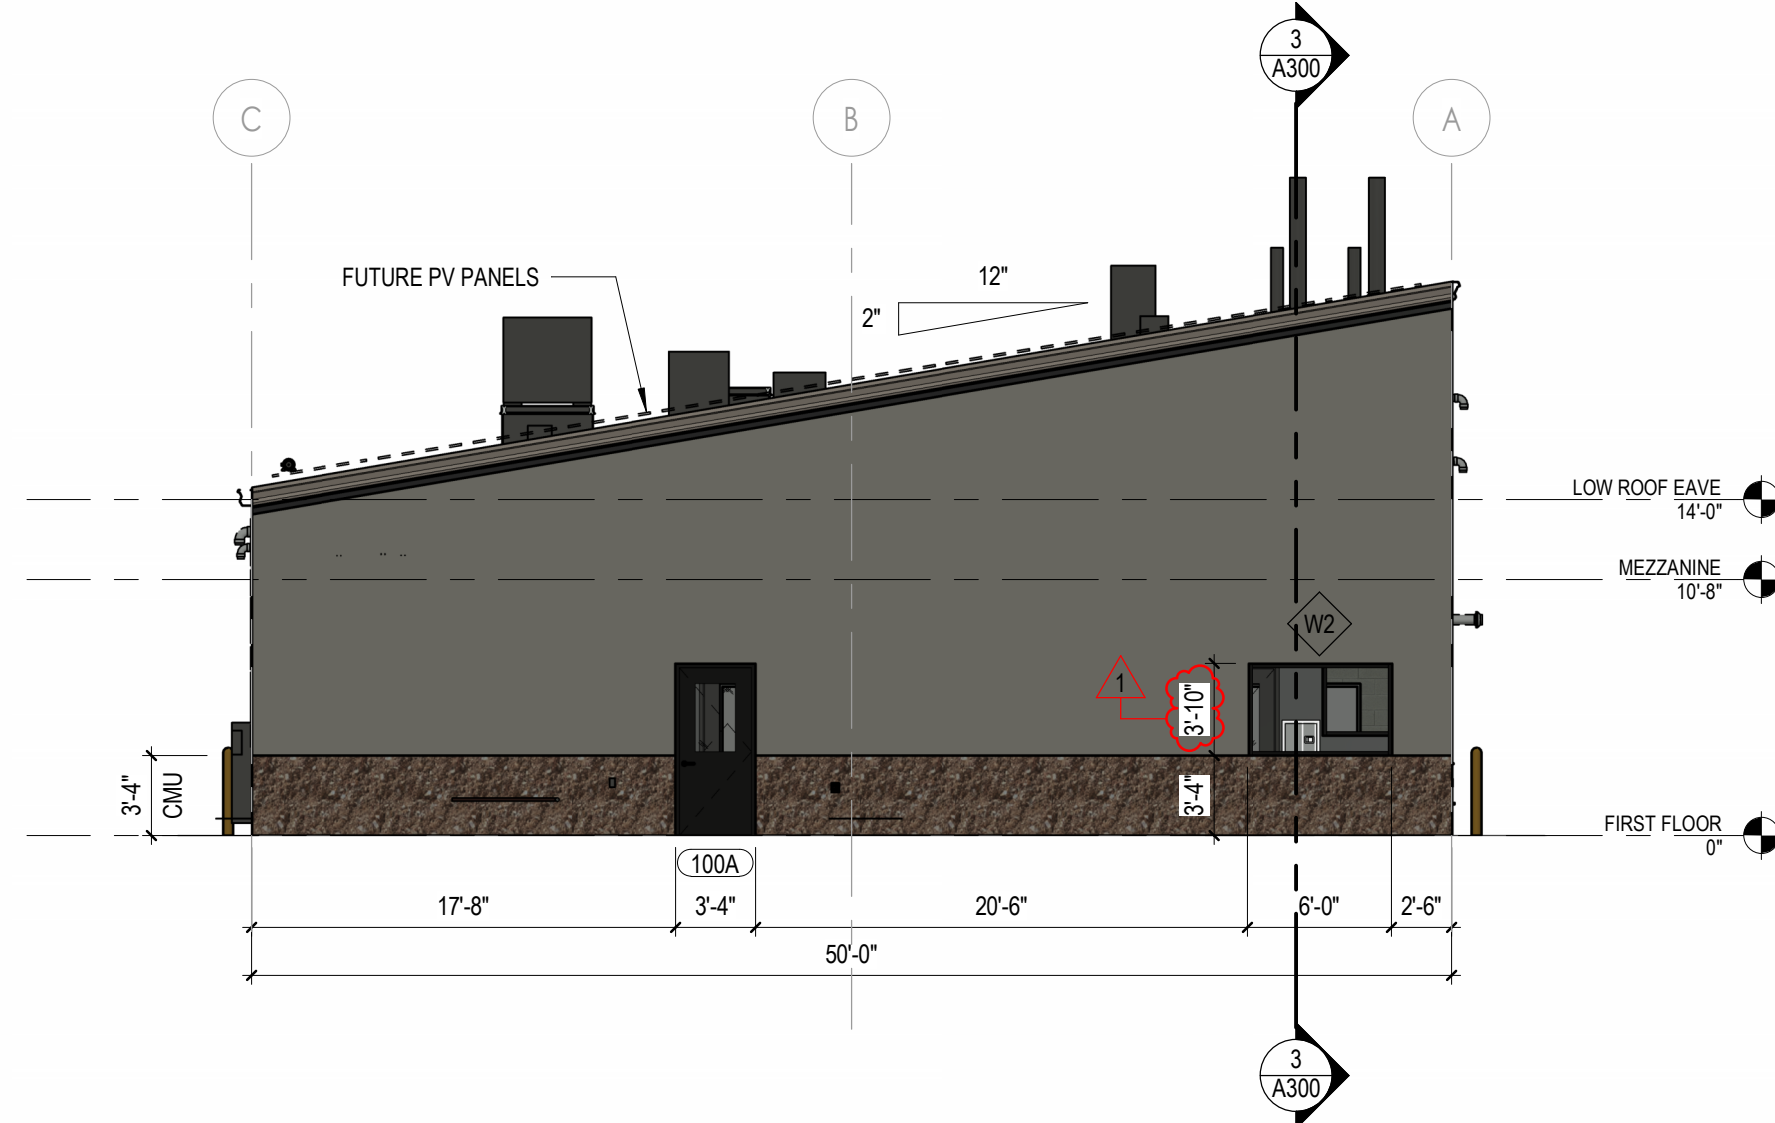


3 EAST ELEVATION

1/8" = 1'-0" REF: 1/ A100

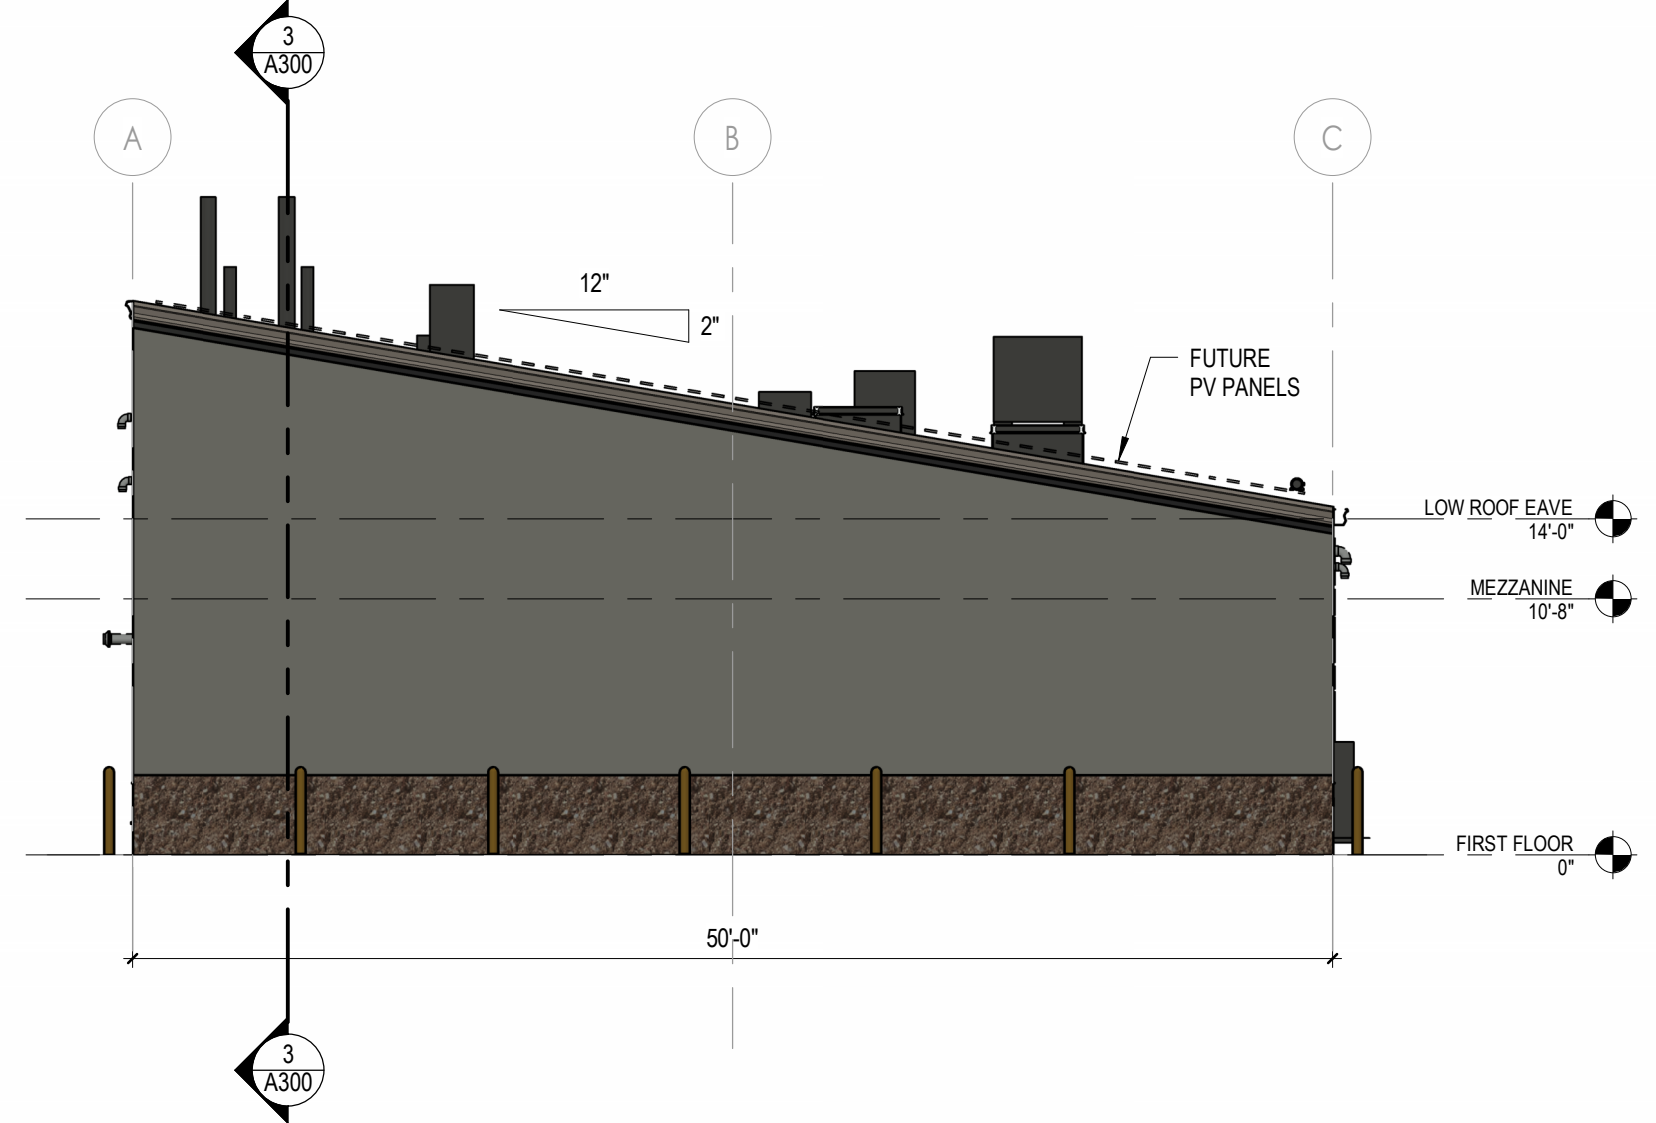

5 WEST ELEVATION

1/8" = 1'-0" REF: 1/ A100

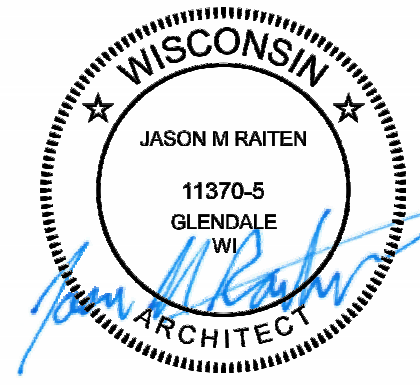

SIGNATURE

PROPRIETARY AND CONFIDENTIAL

This drawing and its contents are the property of Performance Services and shall not be reproduced in whole or in part by any means, mechanical or electronic, without express written permission.



New Construction of
EAST TROY TRANSPORTATION BUILDING
2021 West St., East Troy, WI 53120
EAST TROY COMMUNITY SCHOOLS
DESIGN BUILD

PSI PROJECT NO. 300-K24-3839
DATE: 03 / 27 / 2025
DRAWN BY: DAB
CHECKED BY: JMR

1 06-12-2025 ASI 01
No. 05-11-2025 CONSTRUCTION SET
DATE DESCRIPTION

REVISIONS
CONSTRUCTION DOCUMENTS

SHEET
A200
EXTERIOR ELEVATIONS



