


Luminaire Schedule				
QTY	TYPE	MFR	PART NUMBER	LLF
40	OW1	Keystone	KT-WPLED35PS-S3-8CSB-VDIM @ 15W	0.950

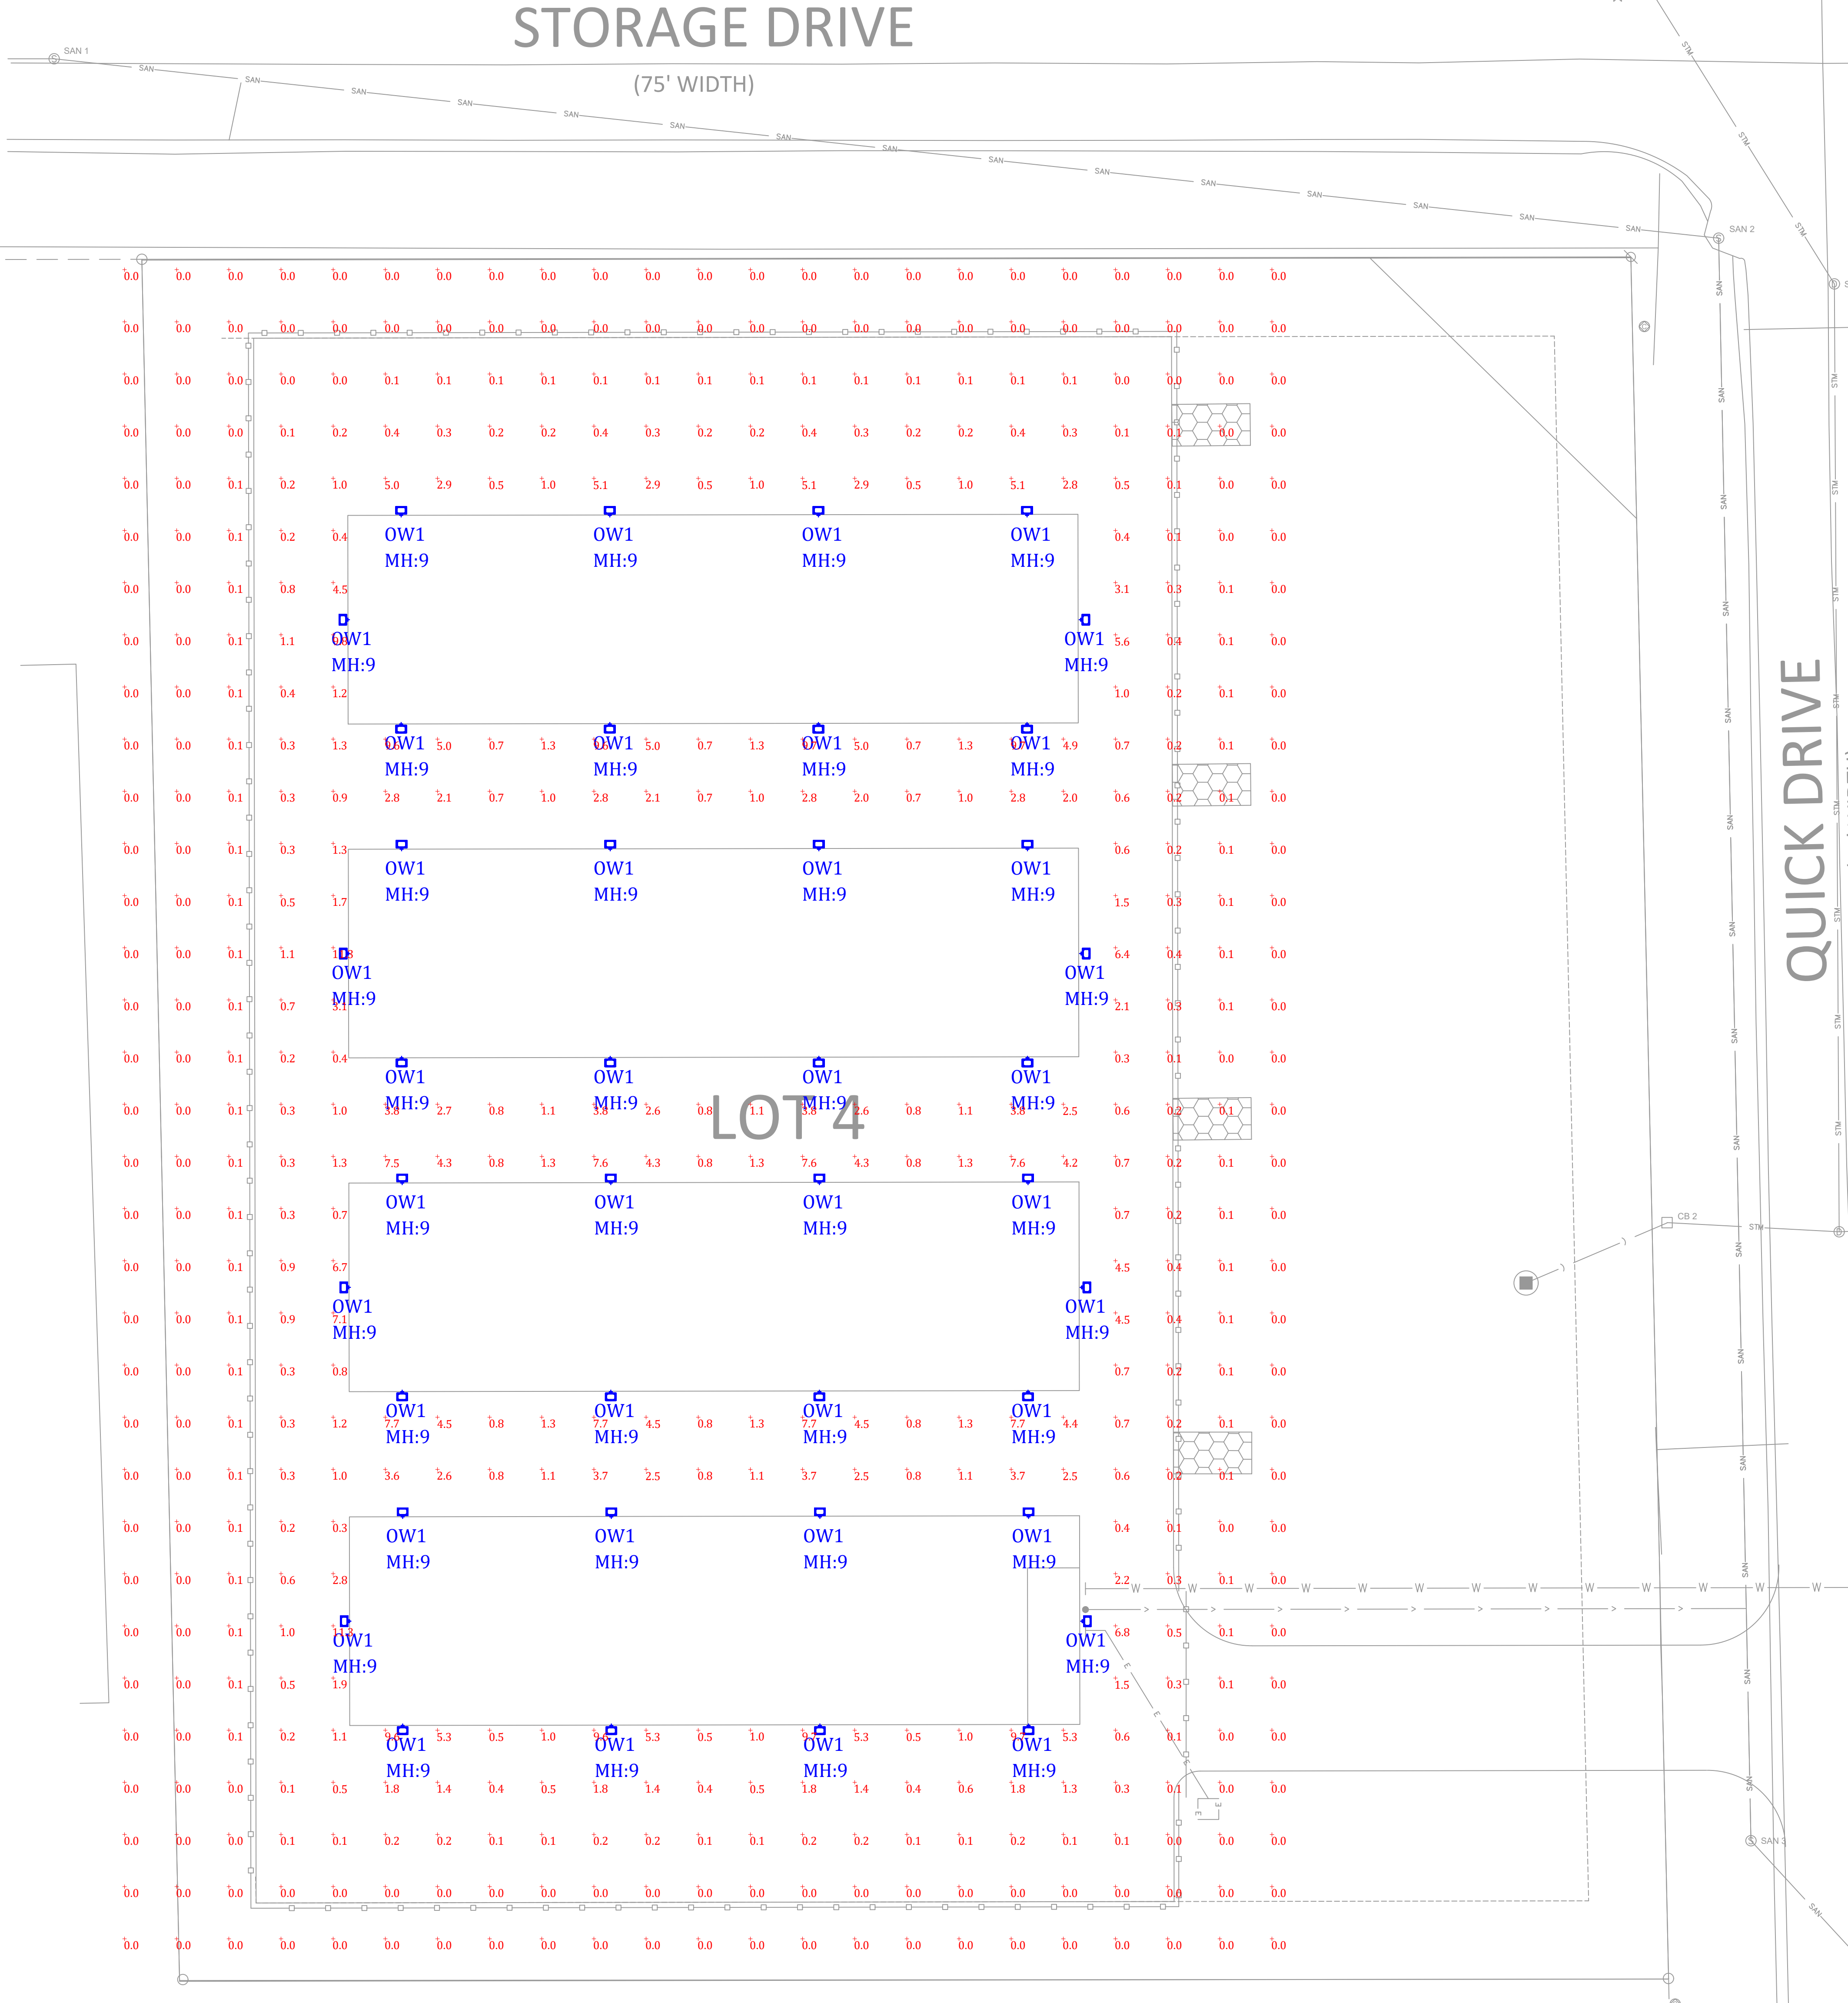

Greenwood Building #1 Mini Storage

CALEDONIA, WI

SITE LIGHTING CALCULATIONS

project info

scale

date

designer

1" = 16'-0"

8 / 27 / 2025

JS

sheet name